


CULVER CITY RANGE


GILLIS & ASSOCIATES ARCHITECTS, INC.

Donald Gillis, AIA
PRINCIPAL-IN-CHARGE

Jack Panichapan, AIA
PROJECT ARCHITECT

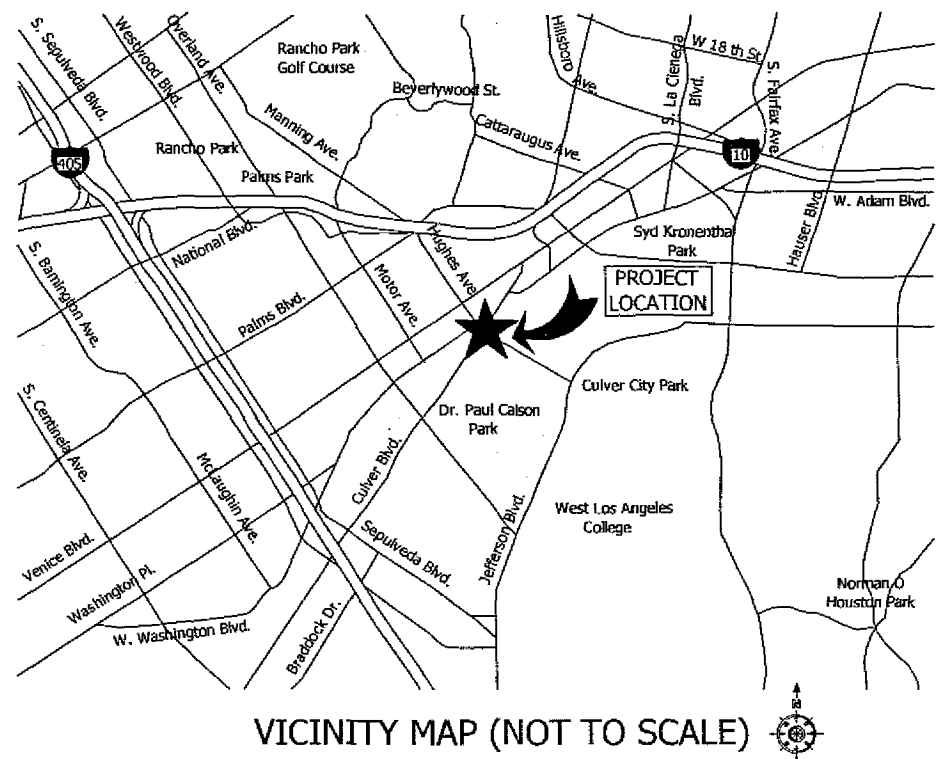

VICINITY MAP (NOT TO SCALE)

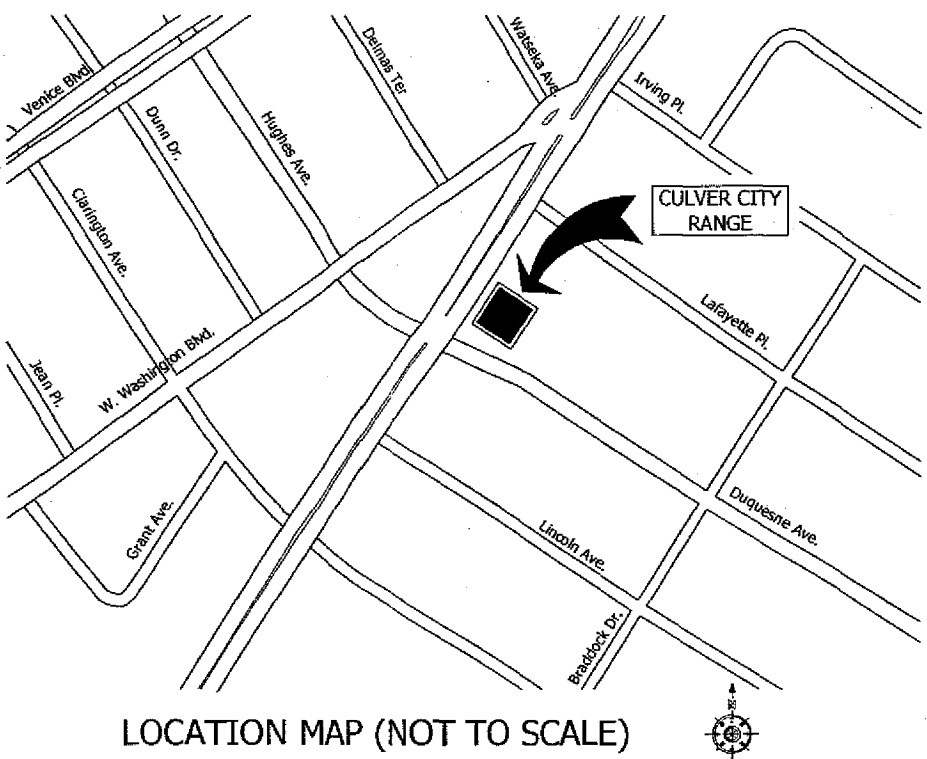

LOCATION MAP (NOT TO SCALE)

SHEET INDEX

ARCHITECTURAL CONCEPT DESIGN:

- 1 Cover Sheet
- 2 Overall Floor Plan
- 3 Existing Floor Plan
- 4 New Floor Plan
- 5 Enlarged Floor Plan
- 6 Section
- 7 Electrical Concept Plan
- 8 HVAC Concept Plan

IMPROVEMENT FACILITY

PHASE II


9770 CULVER BOULEVARD, CULVER CITY, CA 90232-0507

GILLIS & ASSOCIATES
ARCHITECTS, INC.
2900 BRISTOL STREET COSTA MESA CALIFORNIA 92626
FAX (714) 668-4265 SUITE G-205 TEL (714) 668-4260



PROGRESS PRINTS			
DRAWN: Staff	DATE: August 2006	© Gillis & Associates Architects All Rights Reserved This document and the structure depicted herein are the copyrighted property of, and may not be reproduced in any form without the express written permission of, Gillis & Associates.	
CHECKED: JAG MDL: JAG			
SC/CTR	FILE		

Improvement Facility
Culver City Range

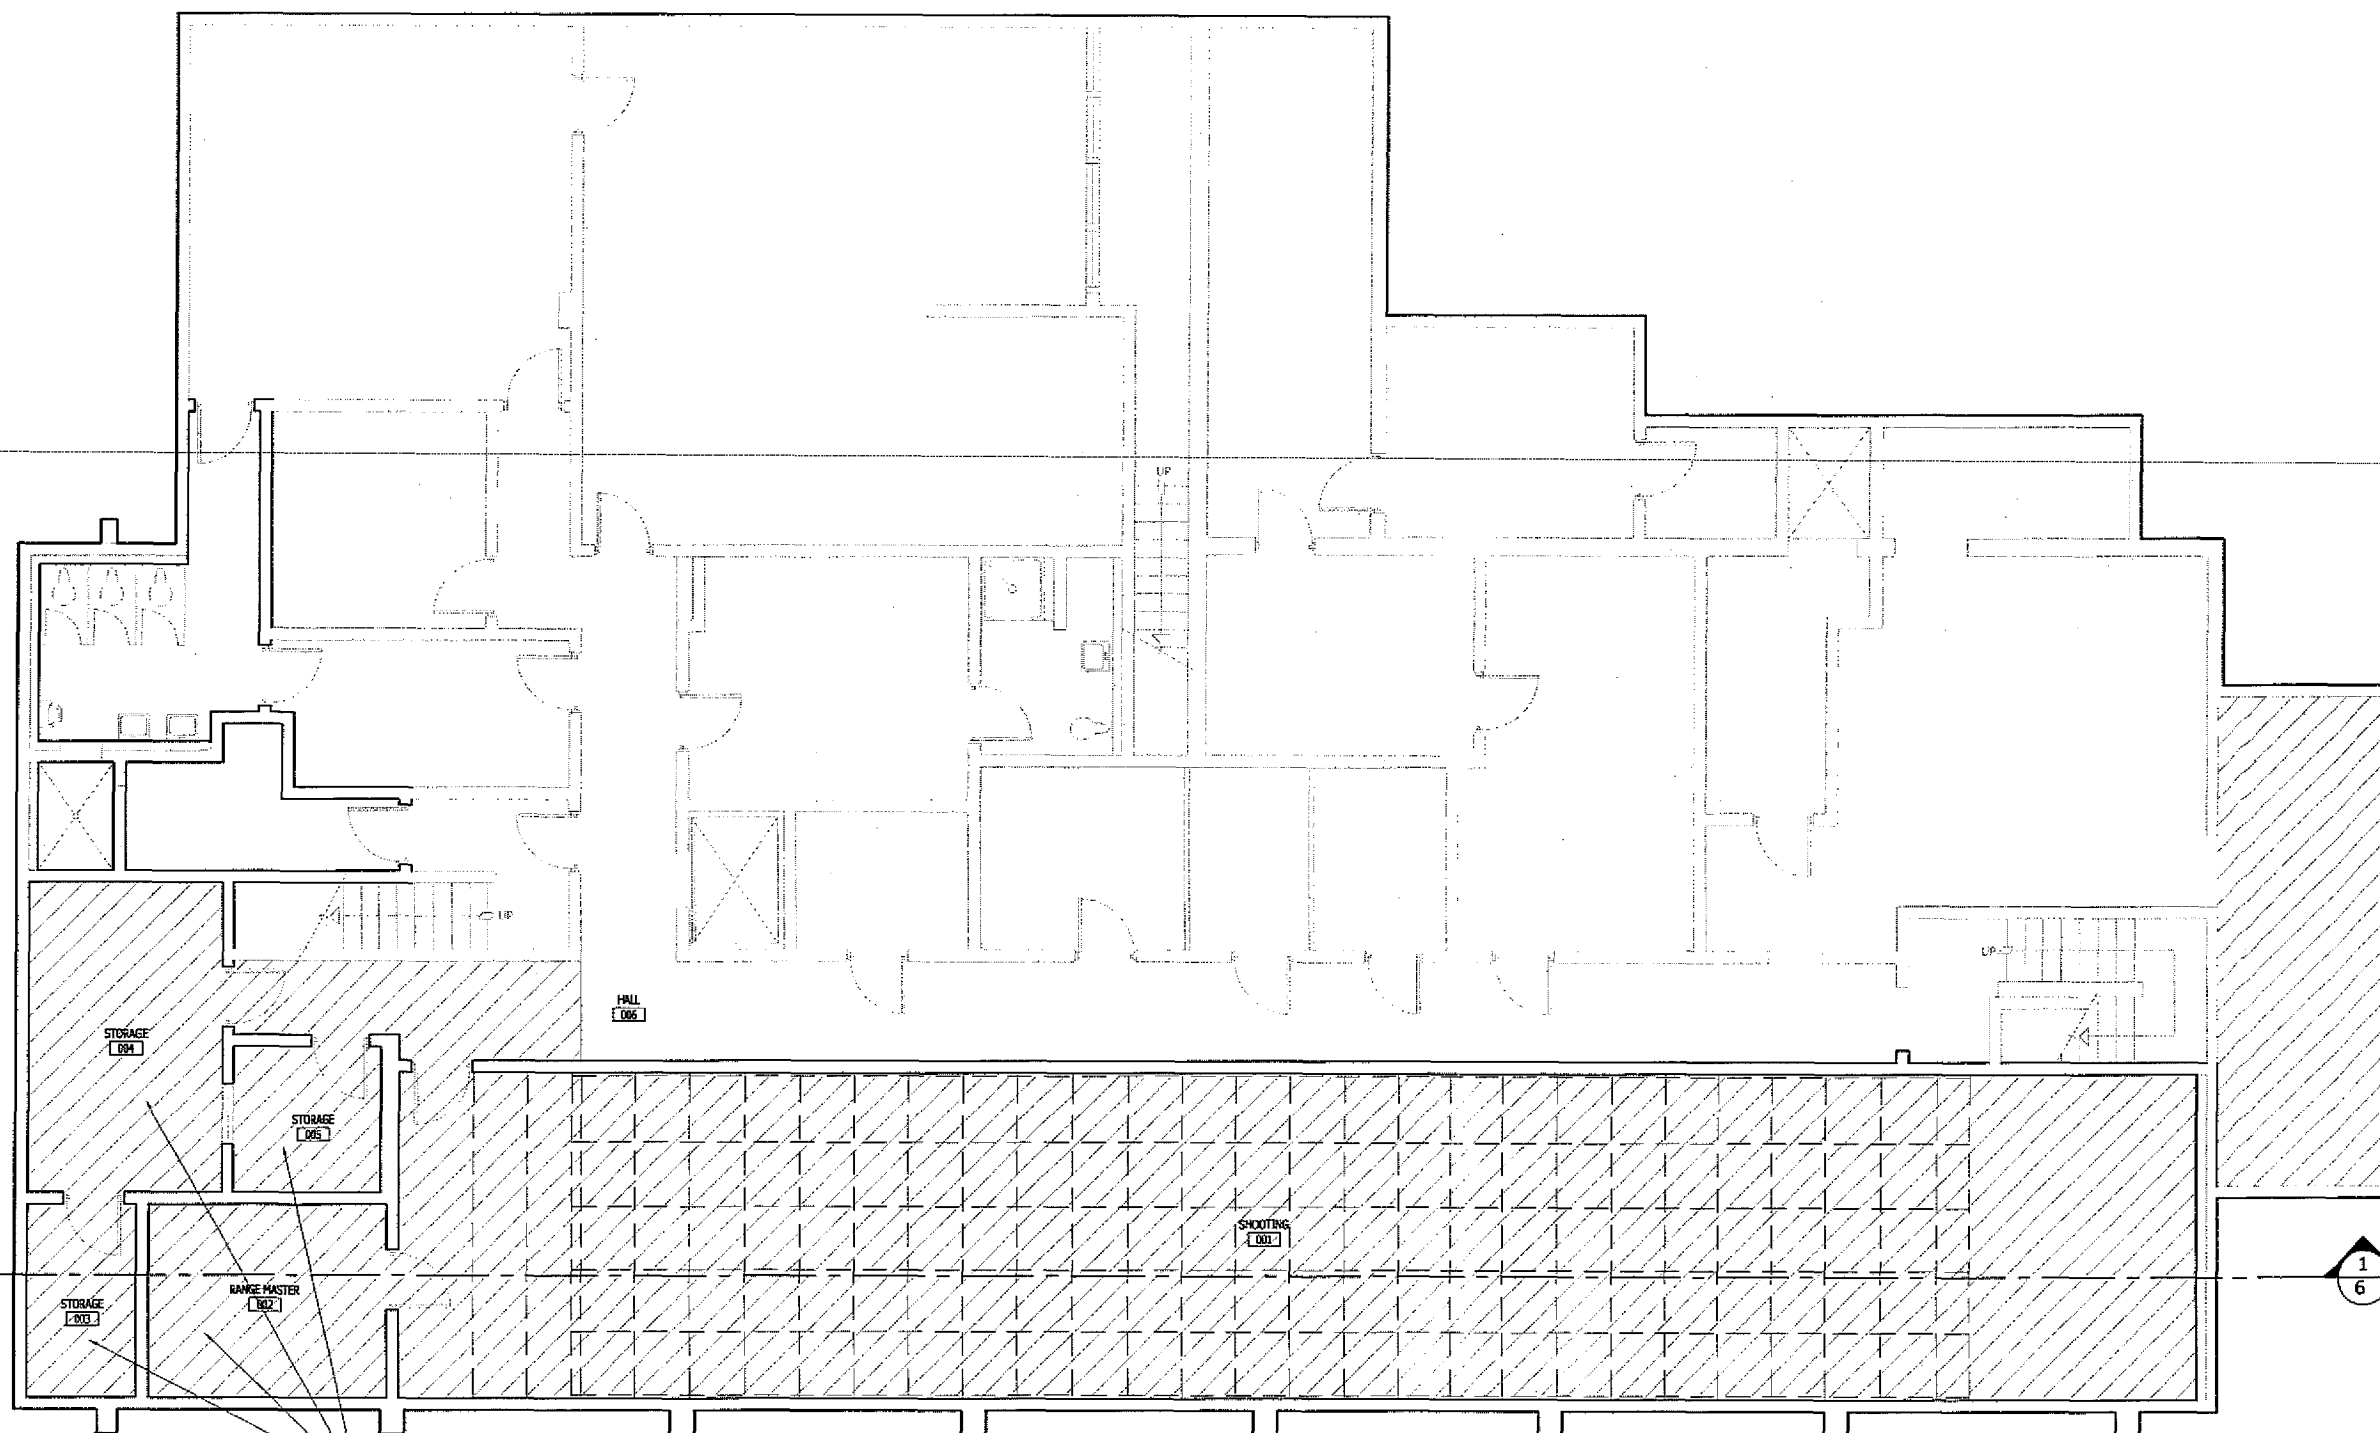

LEGEND:




INDICATING SCOPE OF WORK

1 OVERALL FLOOR PLAN & SCOPE OF WORK
Scale: 3/16" = 1'-0"

GILLIS & ASSOCIATES ARCHITECT & INC. 2900 BRISTOL STREET COSTA MESA, CALIFORNIA 92626 FAX (714) 668-4265 SUITE G-205 TEL (714) 668-4260		
PROGRESS PRINTS		
DRAWN: Staff CHECKED: RLE SCALE:	DATE: August 2005 JOB NO.: 2404 RLE	This document and the structure described herein are the copyrighted property of, and may not be reproduced in any form without the written permission of, Gillis & Associates.

Improvement Facility
Cuver City Range

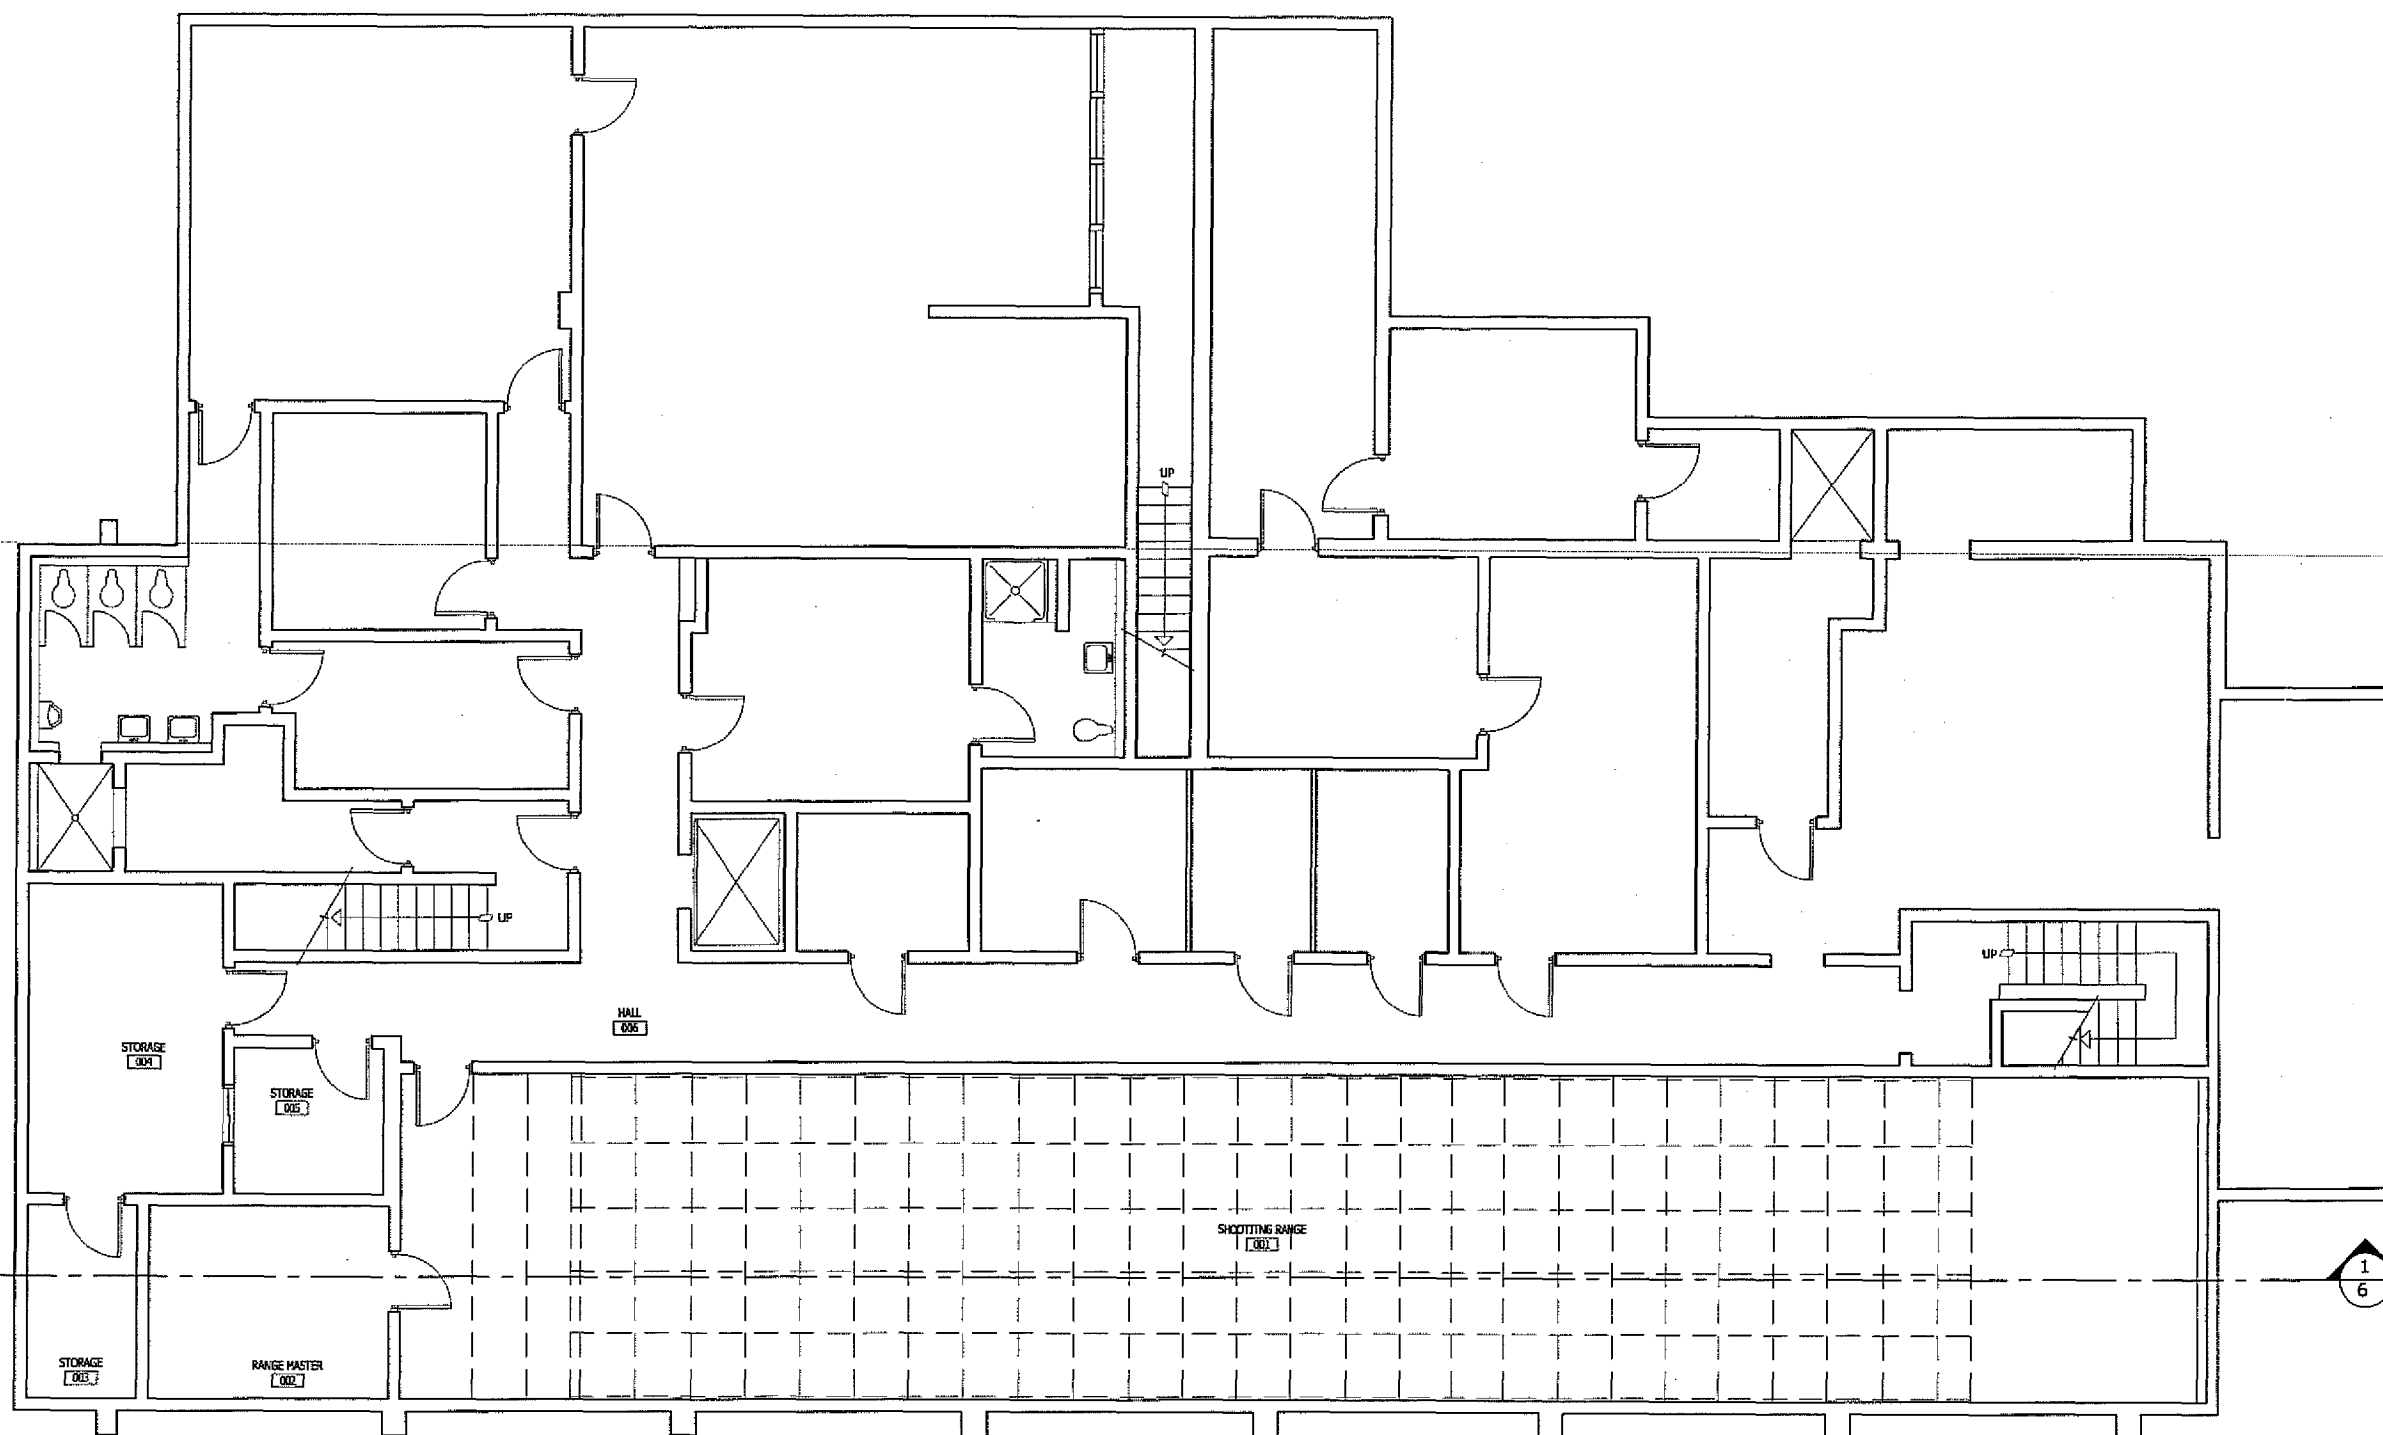

1 EXISTING FLOOR PLAN
Scale: 3/16" = 1'-0"

GILLIS & ASSOCIATES ARCHITECT & INC. 2900 BRISTOL STREET COSTA MESA, CALIFORNIA 92626 FAX (714) 668-4265 SUITE G-205 TEL (714) 668-4260		
PROGRESS PRINTS		
DRAWN: Staff CHECKED: JGB SC: PCT	DATE: August 2006 JOB NO.: 2404 FILE	© Gillis & Associates Architects All Rights Reserved This document and the structure depicted herein are the copyrighted property of, and may not be reproduced in any form without the express written permission of, Gillis & Associates.

Improvement Facility
Culver City Range

KEY NOTES:

1. NO STRUCTURAL CHANGES TO THE BUILDING.

2. PROVIDE AND INSTALL A BULLET TRAP.

3. PROVIDE AND INSTALL OVERHEAD BAFFLES.

4. PROVIDE AND INSTALL NEW HVAC SYSTEM.

5. PROVIDE AND INSTALL REQUIRED ELECTRICAL.

6. PROVIDE AND INSTALL BALLISTIC RUBBER WALL SURFACE.
- 01 BALLISTIC RUBBER TRAP OR HELICAL TRAP.

02 NEW HVAC SYSTEM.

03 BALLISTIC COVERED WALL SURFACE.

04 LINES DENOTE LANES FOR RANGE.


05 OVERHEAD METAL BAFFLES.

06 CLOSE IN EXISTING DOOR OPENING.

07 NEW BULLETPROOF DOOR AND FRAME.

08 NEW BULLETPROOF FRAME AND GLAZING.

09 NEW BULLETPROOF DOOR AND FRAME.

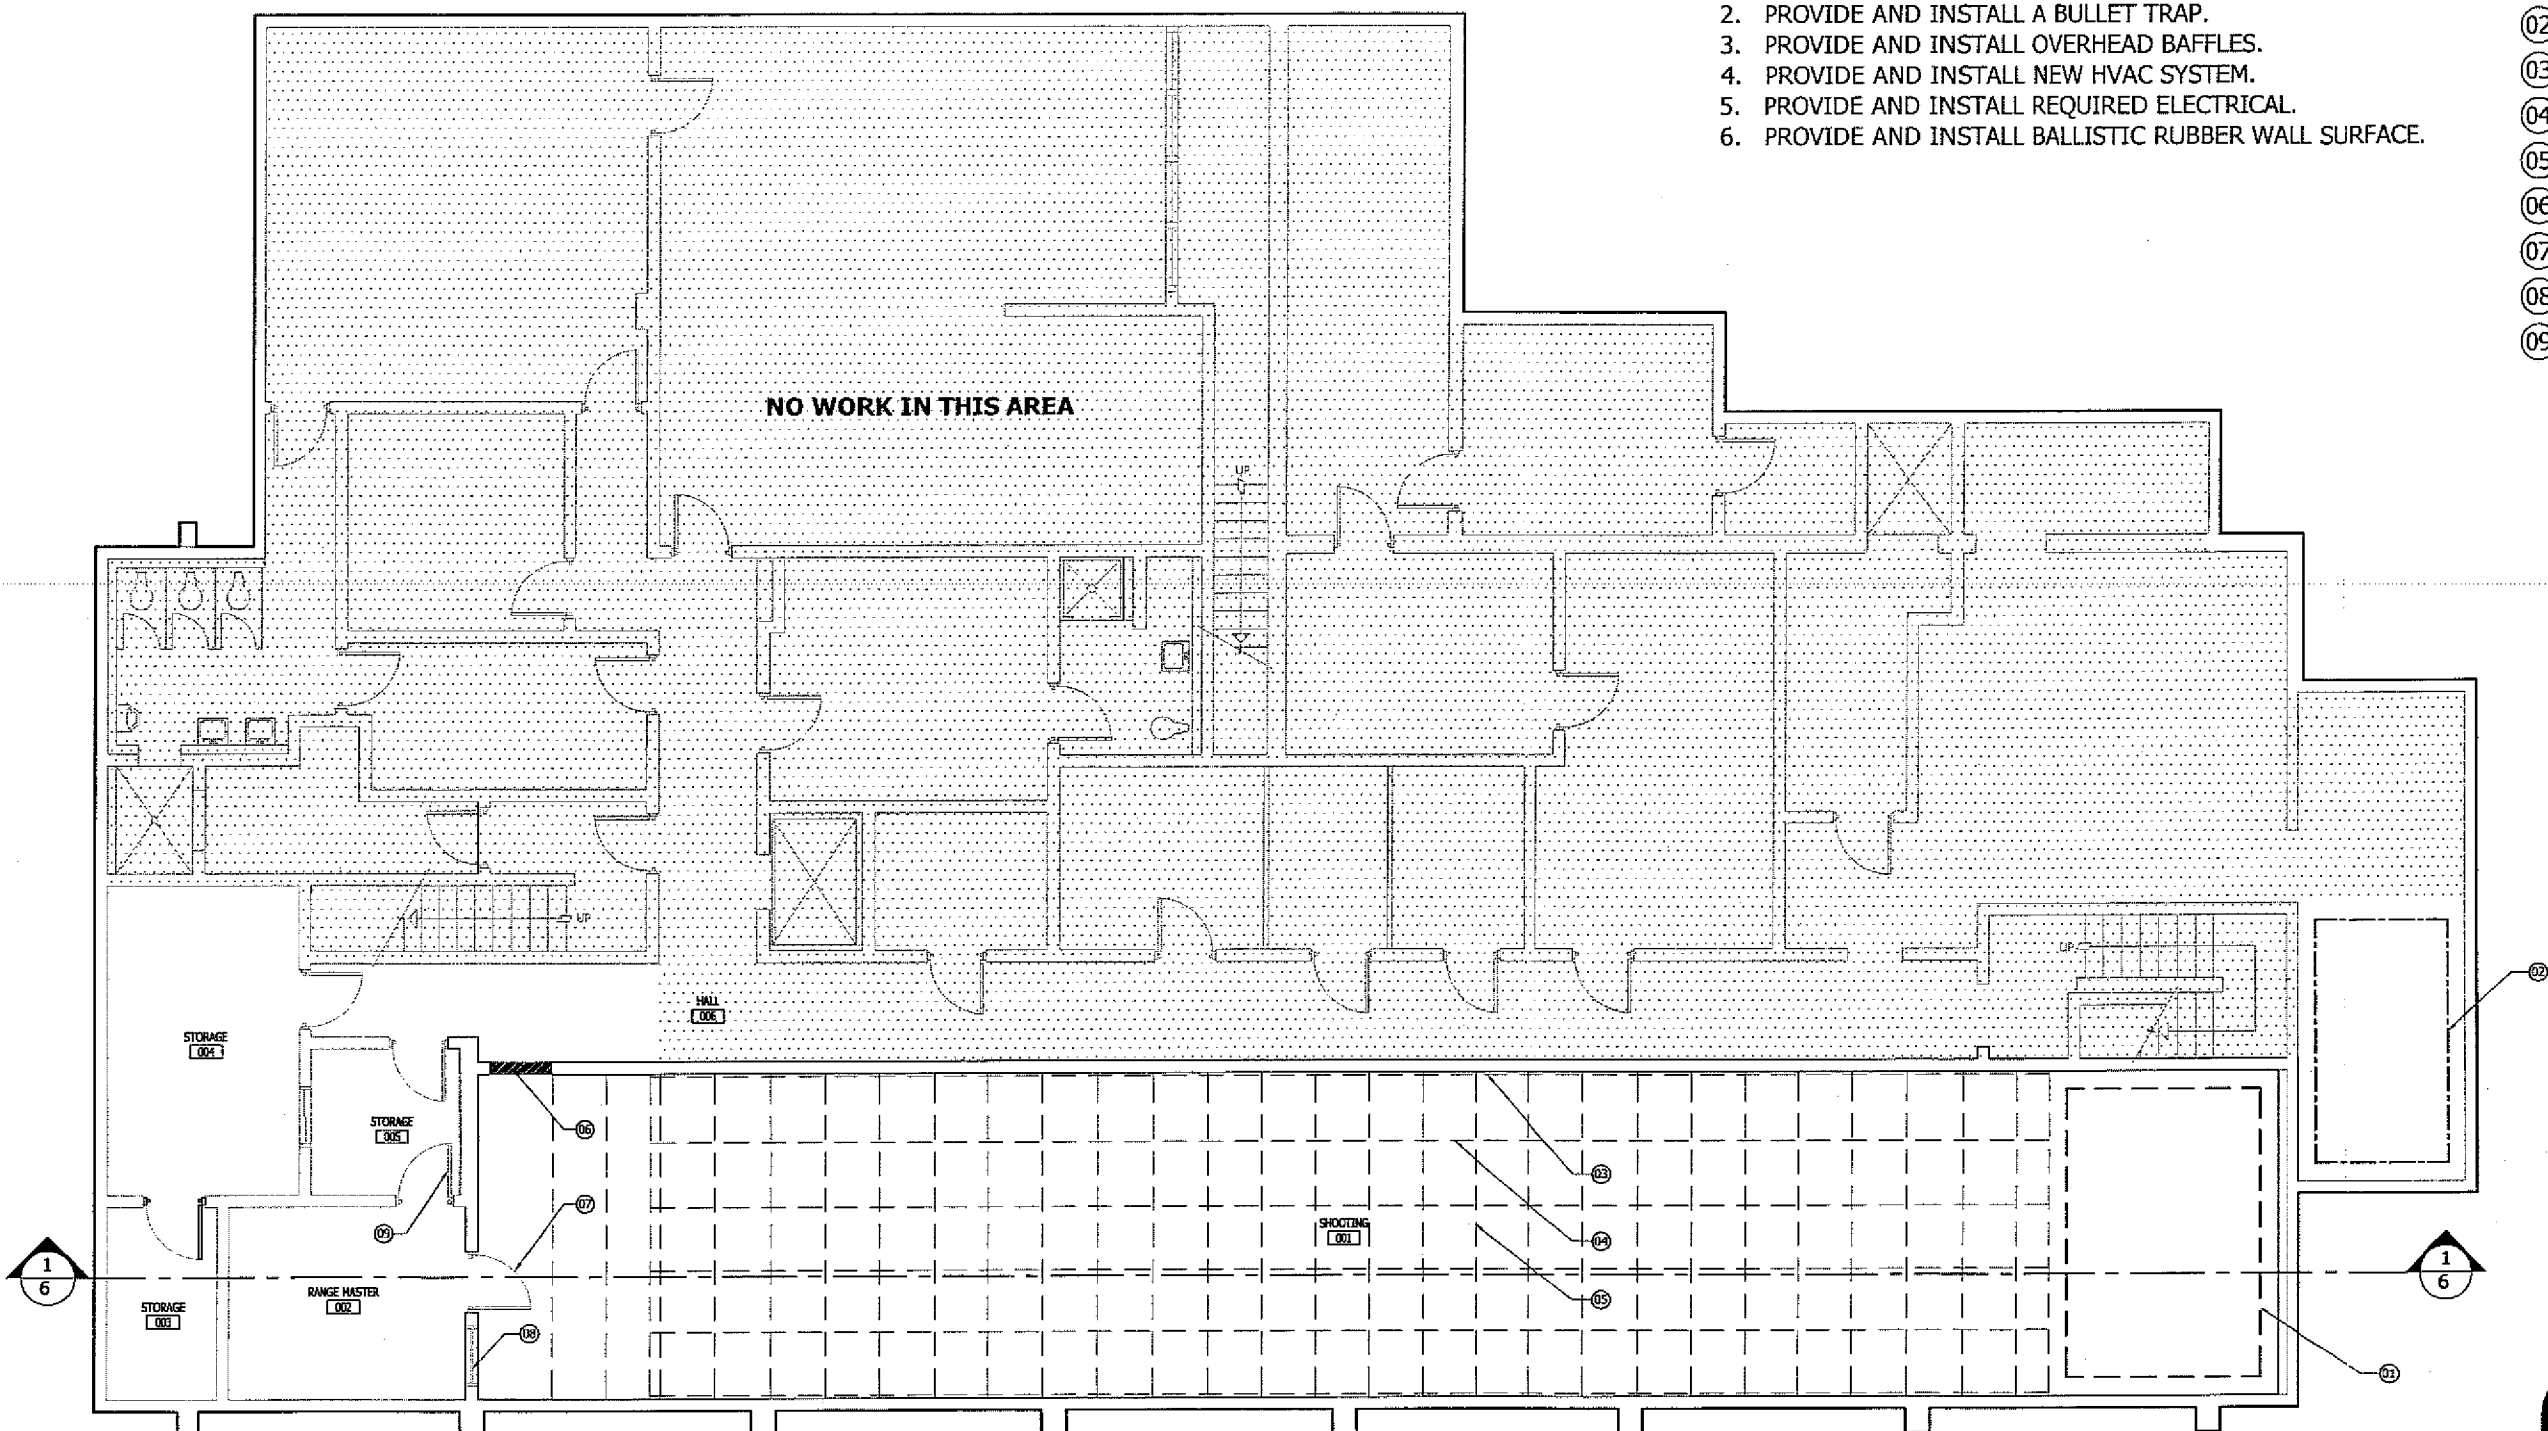

1 NEW FLOOR PLAN
Scale : 3/16" = 1'-0"

GILLIS & ASSOCIATES
ARCHITECT & INC.

2900 BRISTOL STREET COSTA MESA CALIFORNIA 92626
FAX (714) 668-4265 SUITE G-205 TEL (714) 668-4260


REGISTERED PROFESSIONAL ARCHITECT
DONALD JOSEPH GILLIS
NO. C-7955
EXP. 11-30-07
STATE OF CALIFORNIA

PROGRESS PRINTS	
DRAWN: Staff	DATE: August 2006
CHECKED: JCB NO.: 2404	
SC FCTR	FILE


Gillis & Associates Architects
All Rights Reserved

This document and the structure depicted herein are the
copyrighted property of, and may not be reproduced in any form
without the express written permission of, Gillis & Associates.

Improvement Facility
Culver City Range

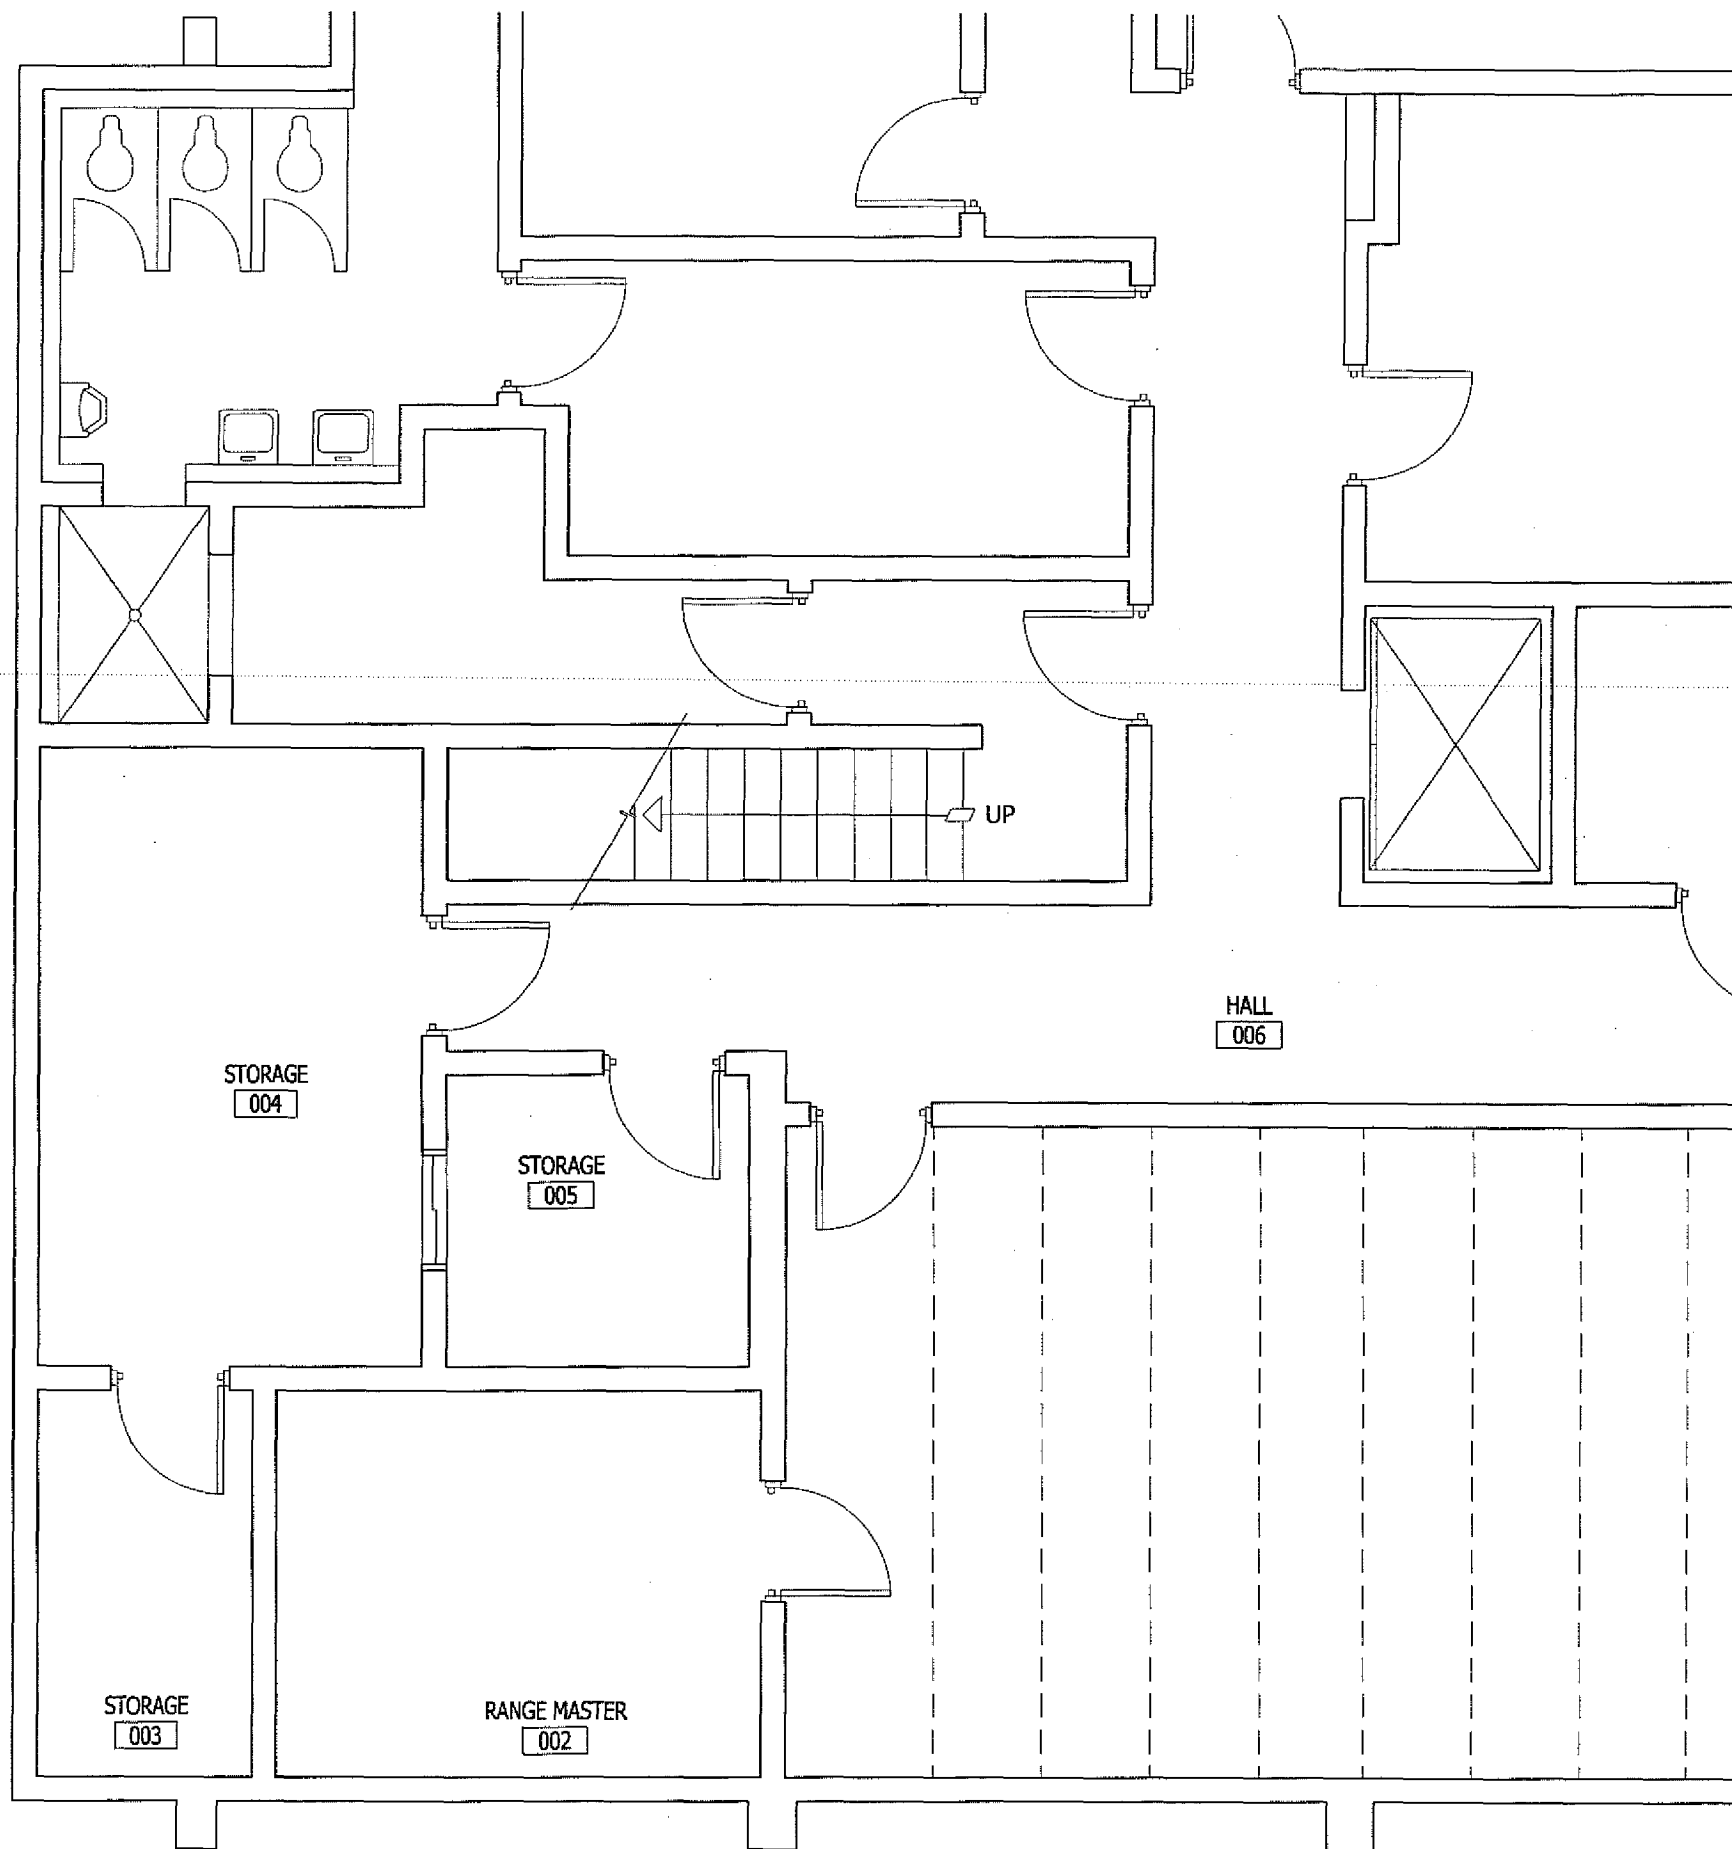

1 ENLARGED EXISTING FLOOR PLAN
Scale: 3/8" = 1'-0"

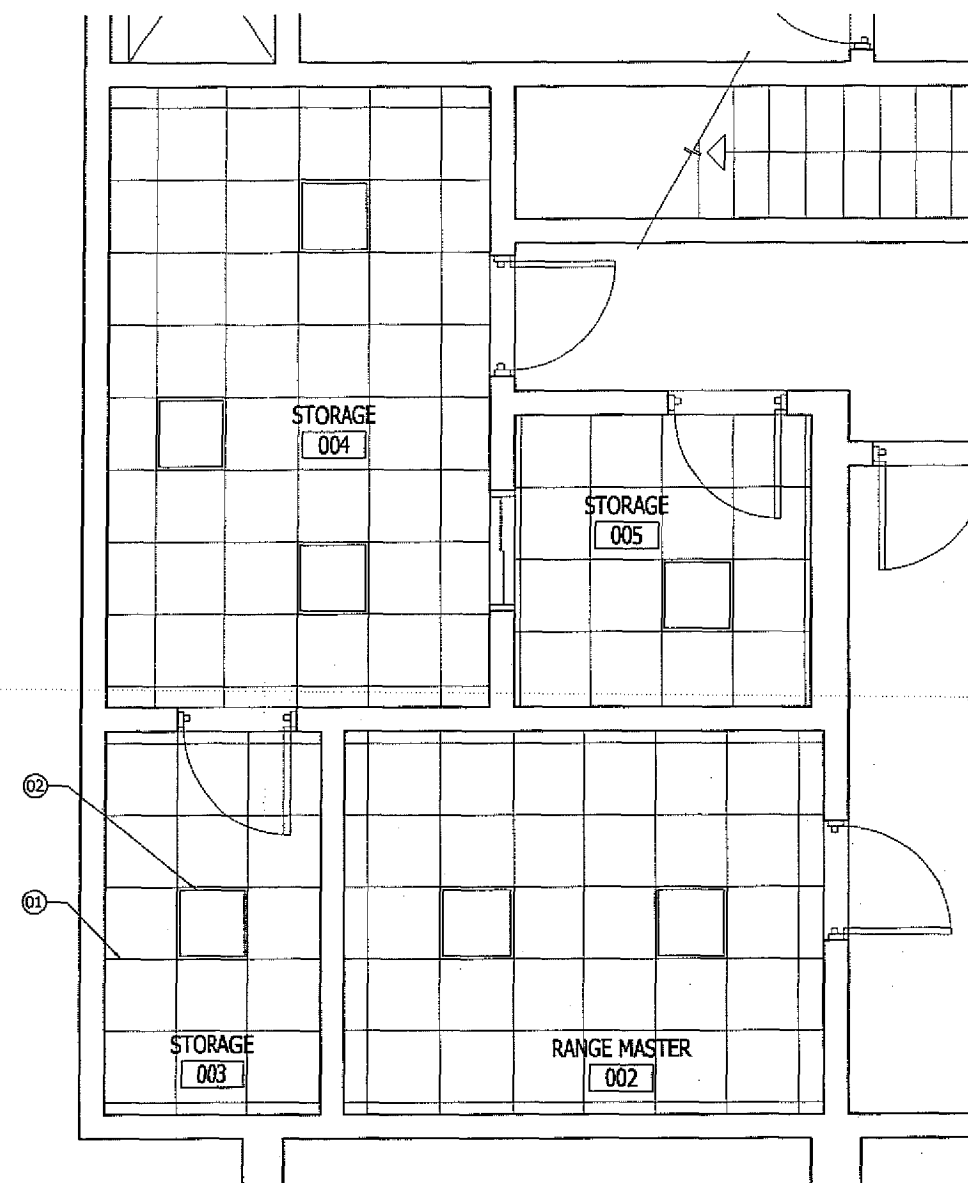

2 PARTIAL REFLECTED CEILING PLAN
Scale: 3/8" = 1'-0"

- KEYNOTES:
- 01 2'X2' CEILING GRID W/ ACOUSTICAL TILES. (NEW)
 - 02 RECESSED 2'X2' FIXTURE IN ACCESSIBLE CEILING. (NEW)


GILLIS & ASSOCIATES
ARCHITECTS INC.

2900 BRISTOL STREET COSTA MESA CALIFORNIA 92626
FAX (714) 668-4265 SUITE G-205 TEL (714) 668-4260

REGISTERED PROFESSIONAL ARCHITECT
DONALD JOSEPH GILLIS
NO. C-7855
EXP. 11-30-07
STATE OF CALIFORNIA

PROGRESS PRINTS			
DRAWN: SHF	DATE: August 2006	Gillis & Associates reserves all rights reserved. This document and the structures depicted herein are the copyrighted property of, and may not be reproduced in any form without the express written permission of, Gillis & Associates.	
CHECKED:	JOB NO.: 2404		
SC FOR:	FILE		


Improvement Facility
Culver City Range

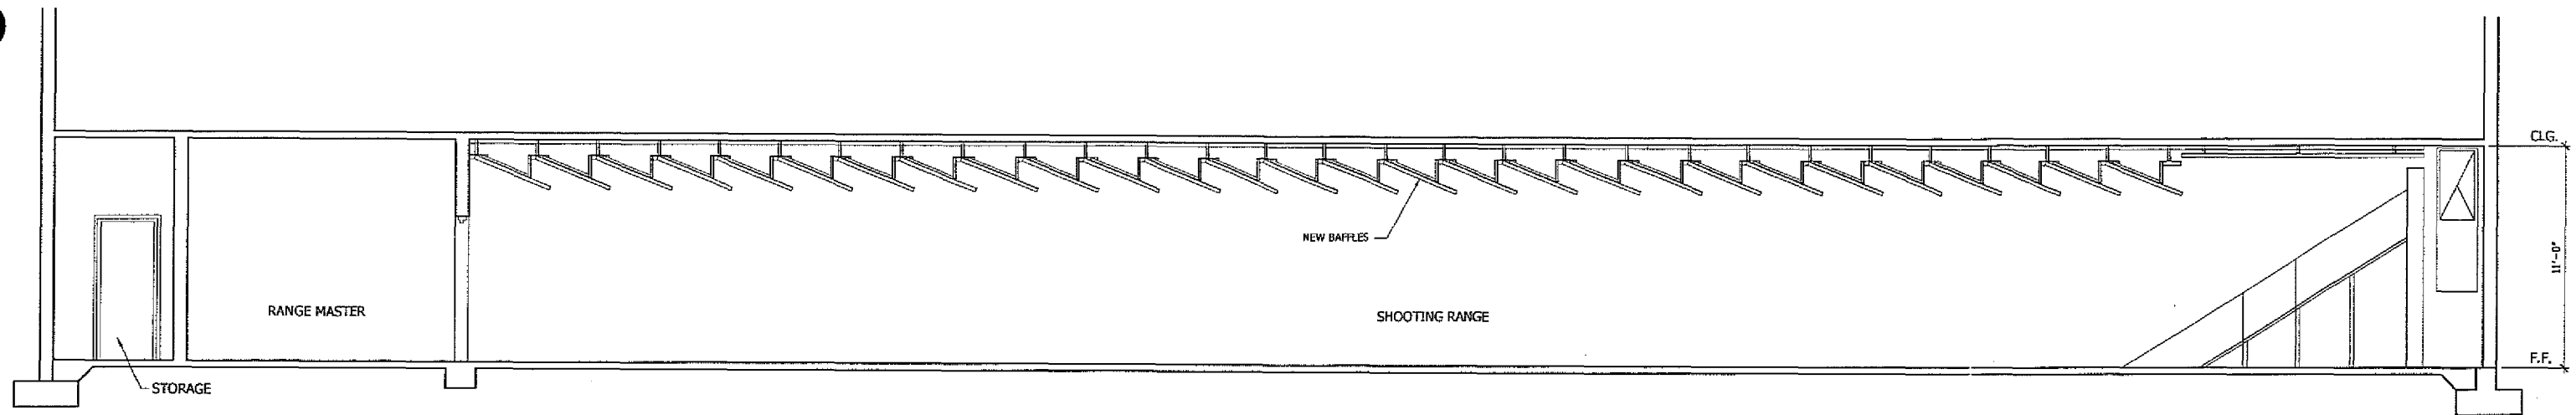

1 SECTION
Scale: 1/4" = 1'-0"

GILLIS & ASSOCIATES ARCHITECTS & INC. 2900 BRISTOL STREET COSTA MESA CALIFORNIA 92626 FAX (714) 668-4265 SUITE G-205 TEL (714) 668-4260		
PROGRESS PRINTS		
DRAWN: Staff	DATE: August 2006	Gillis & Associates Architects All Rights Reserved This document and the structure depicted herein are the copyrighted property of, and may not be reproduced in any form without the express written permission of, Gillis & Associates.
CHECKED:	JOB NO: 2494	
SC/CTR	FILE	

Improvement Facility
Culver City Range

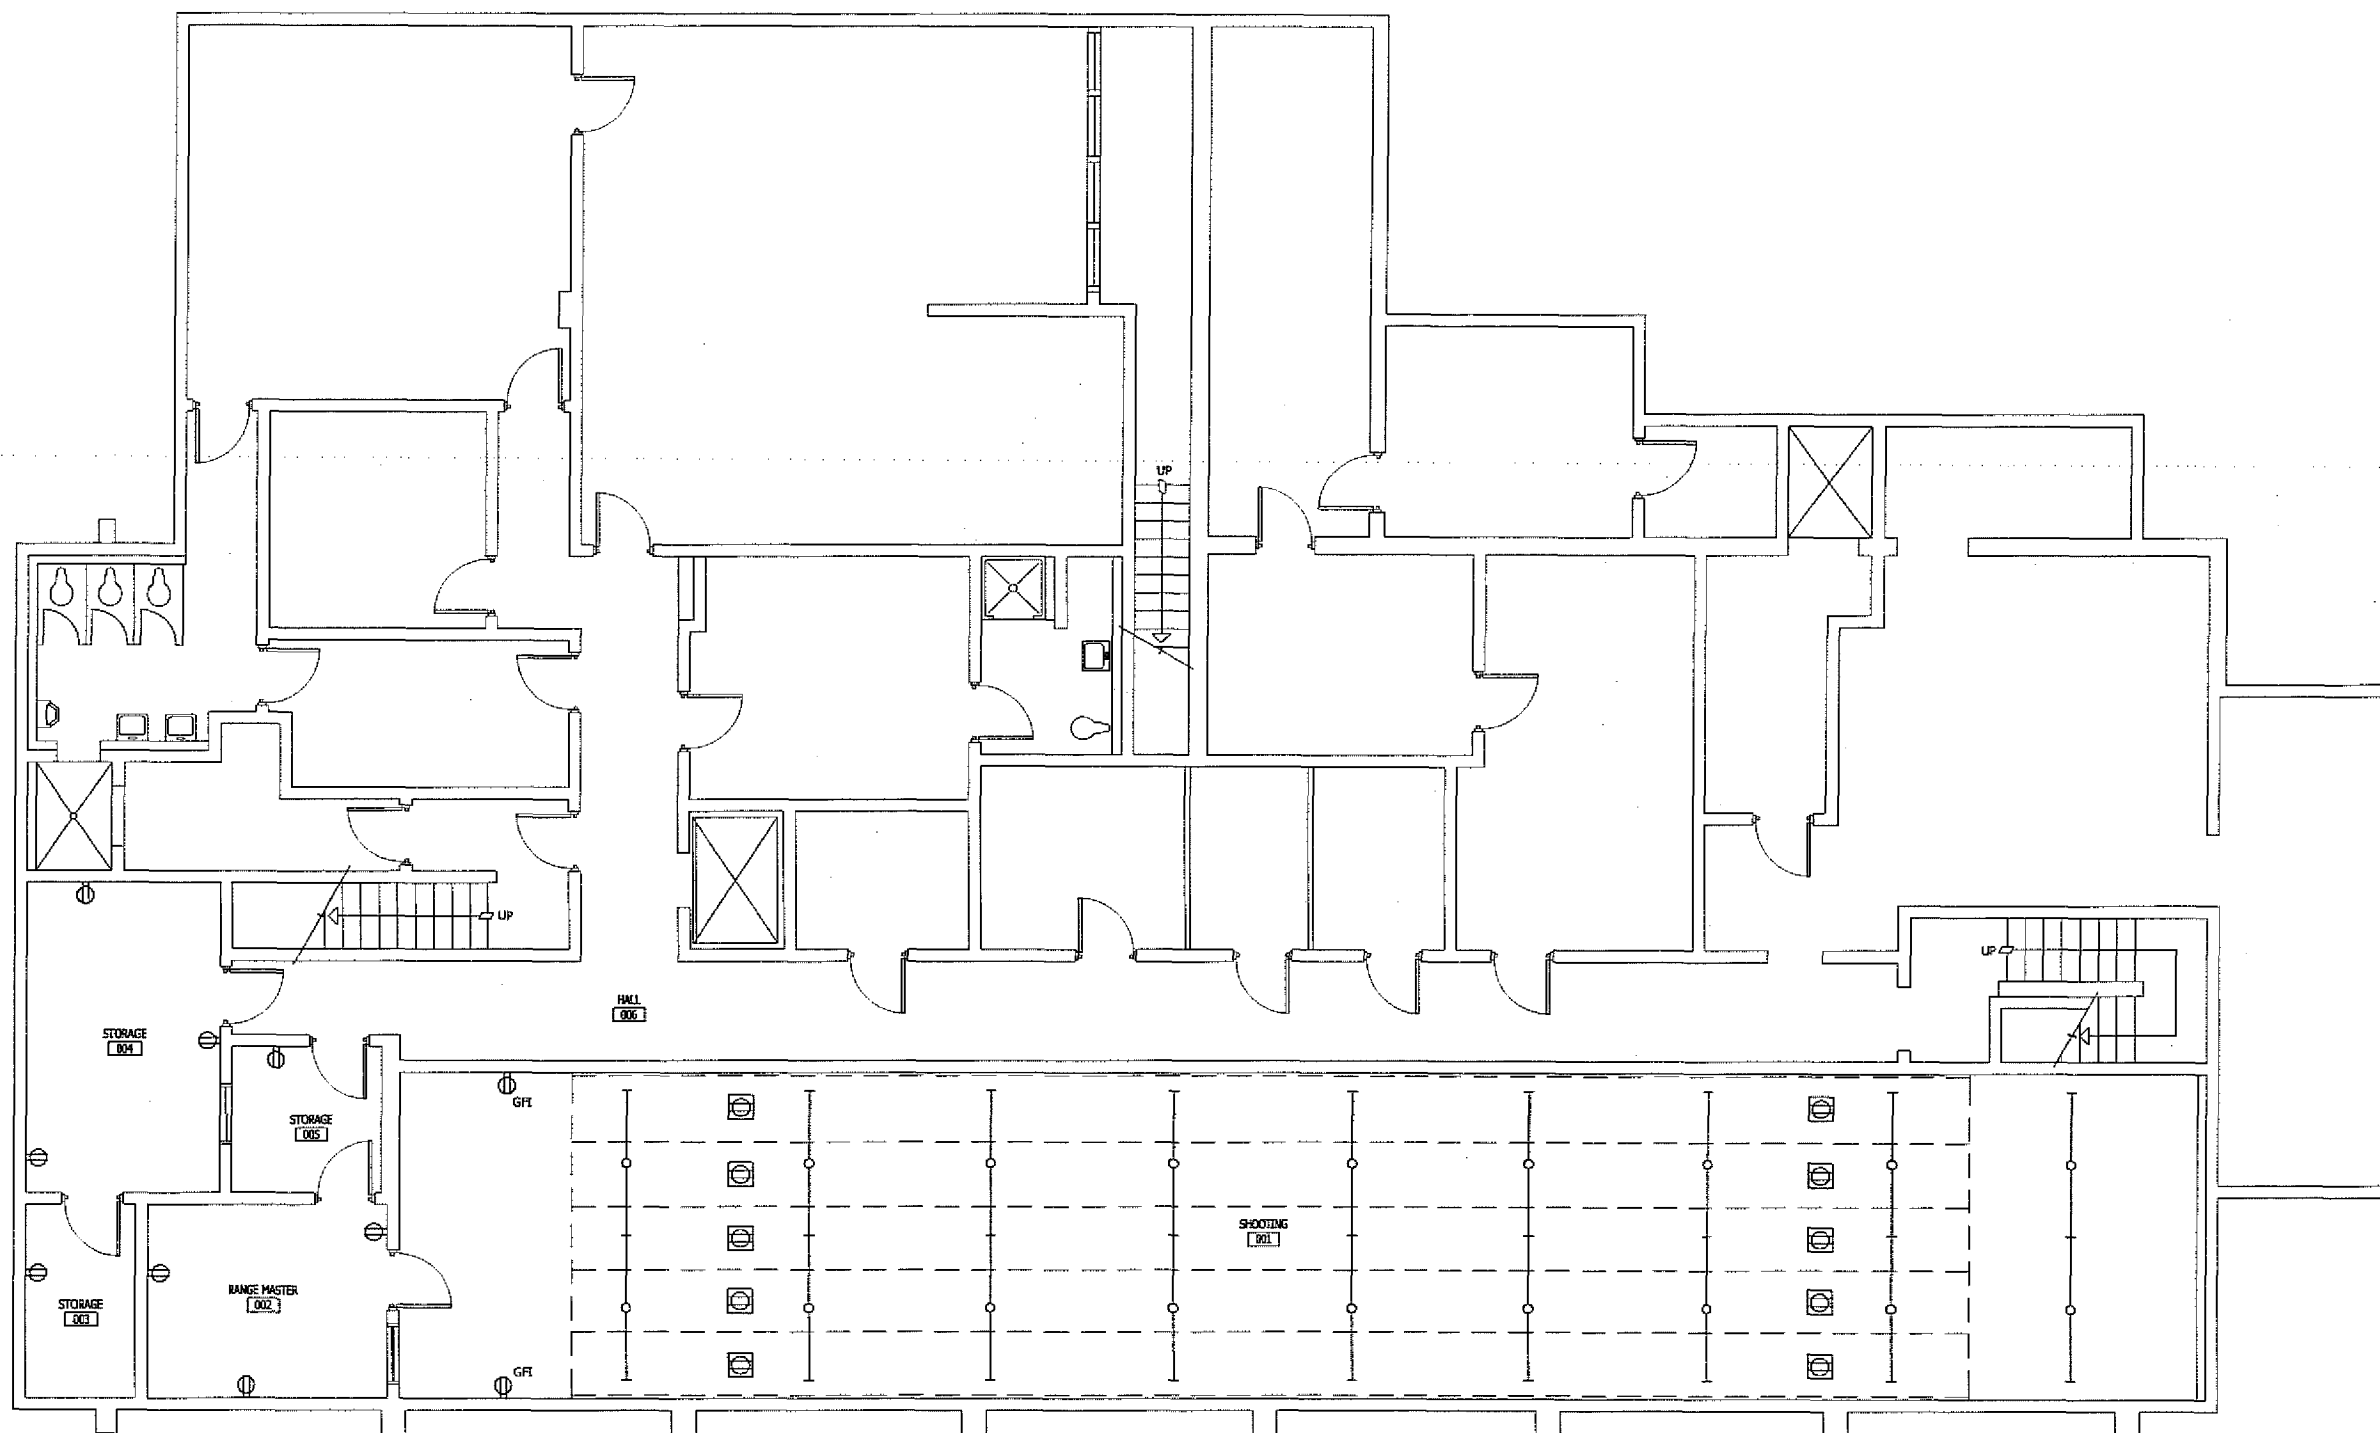


ELECTRICAL LEGEND:

-  CEILING MOUNTED RECEPTACLE @ 60 FOOT LINE FOR MOTORIZED TARGETING SYSTEM (TYP., 5 QTY. EACH LINE)
-  DUPLEX RECEPTACLE, WALL MOUNTED AT +18" A.F.F. OR AS NOTED
-  GFI GROUND FAULT INTERRUPTER RECEPTACLE, WALL MOUNTED AT +18" A.F.F. OR AS NOTED
-  TELEPHONE OUTLET BOX, WALL MOUNTED AT +18 A.F.F. (MIN.) OR AS NOTED STUB A 3/4" C.O. UP 6" ABOVE THE ACCESSIBLE CEILING AND PROVIDE A BUSHING. 45/DP MINIMUM W/ SINGLE GANG RING
-  DATA OUTLET BOX MOUNTED AT +18 A.F.F. (MIN.) OR AS NOTED STUB A 3/4" C.O. UP 6" ABOVE THE ACCESSIBLE CEILING AND PROVIDE A BUSHING. 45/DP MINIMUM W/ SINGLE GANG RING
-  COMMERCIAL WIDE STRIP FLUORESCENT FIXTURE ELECTRONIC BALLAST, U.L. LISTED, SPECIAL DIMMING BALLASTS FROM LITRON


GILLIS & ASSOCIATES
ARCHITECTS & INC.

2900 BRISTOL STREET COSTA MESA CALIFORNIA 92626
FAX (714) 668-4265 SUITE G-205 TEL (714) 668-4260

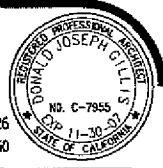

PROGRESS PRINTS	
DRAWN: SALT	DATE: August 2006
CHECKED: SCFCR	JOB NO.: 2404
	FILE

Gillis & Associates Architects
All Rights Reserved
This document and the structure depicted herein are the copyrighted property of, and may not be reproduced in any form without the express written permission of, Gillis & Associates.

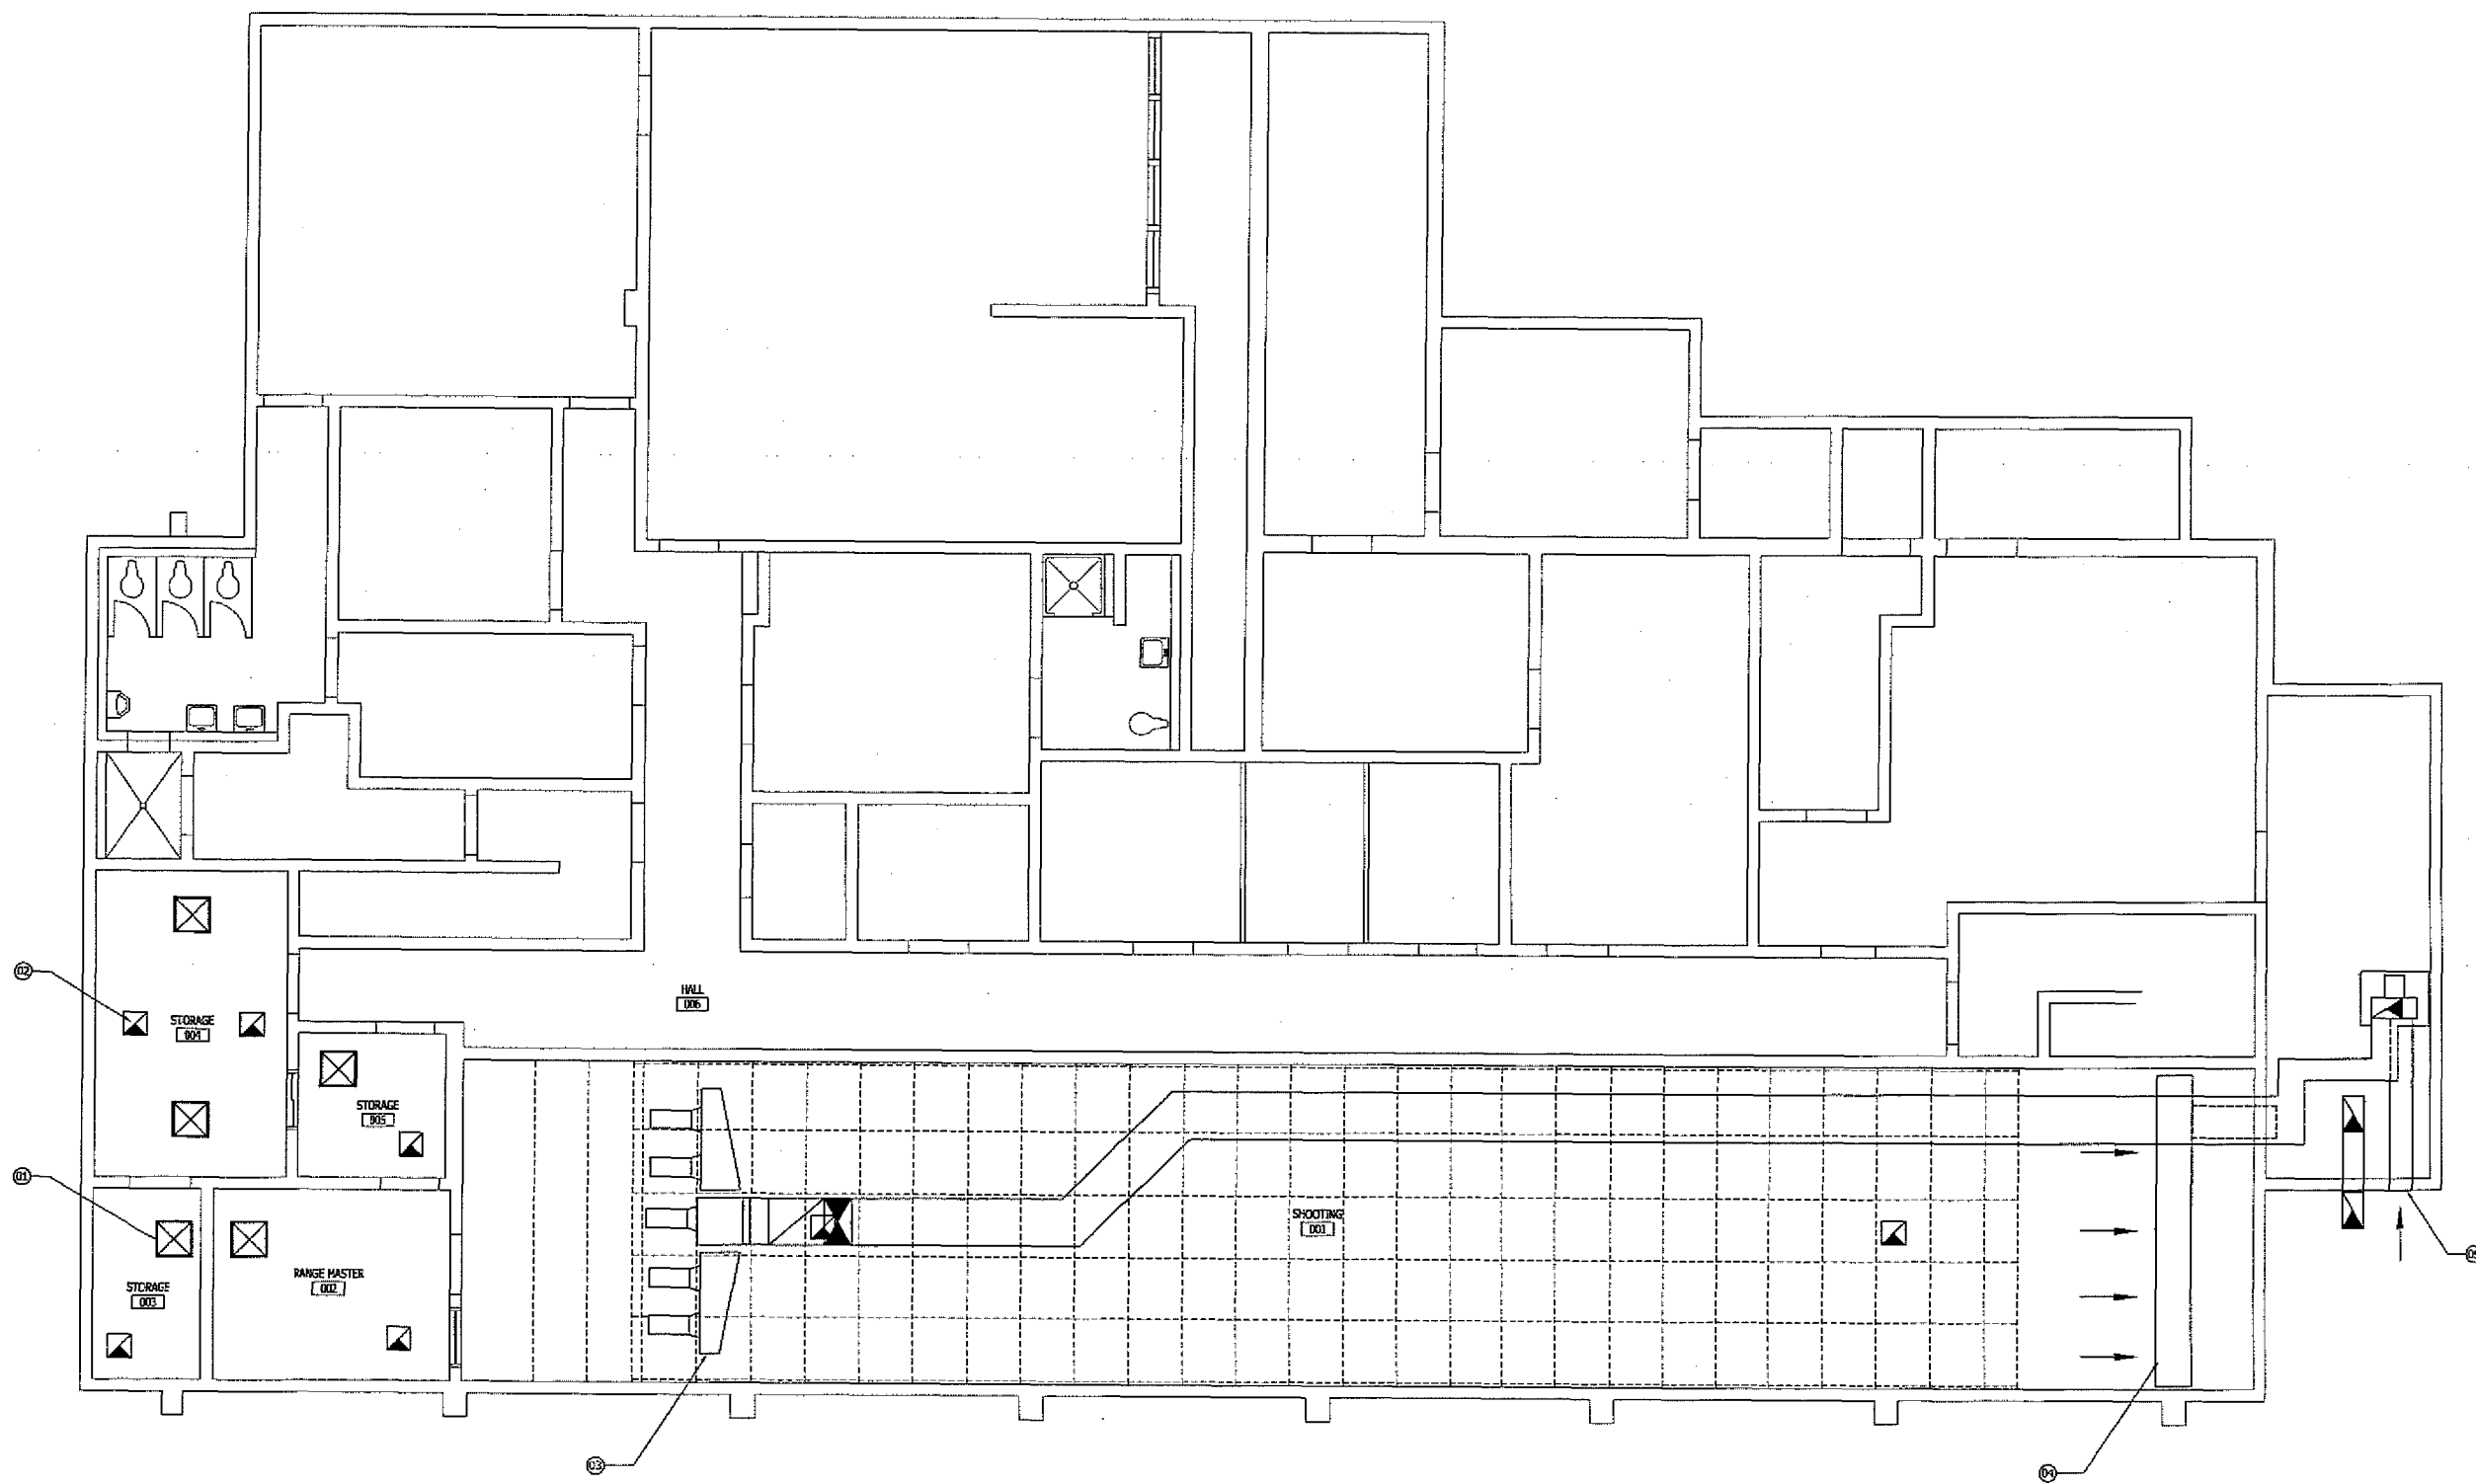

MECHANICAL LEGEND:

- ☒ CEILING DIFFUSER
- ☒ RISER, EXHAUST AIR DUCT

KEYNOTES:

- 01 CEILING DIFFUSER.
- 02 RISER, EXHAUST AIR DUCT.
- 03 SUPPLY DUCT DISTRIBUTES AIR INTO CEILING PLENUM WITH EGG CRATE OR PERFORATED SHEET METAL DISTRIBUTION.
- 04 SUPPORT EXHAUST INLET PLENUM FROM THE FLOOR.
- 05 LOW FILTERED SUPPLY AIR INLET.

GILLIS & ASSOCIATES ARCHITECT & INC. 2900 BRISTOL STREET COSTA MESA, CALIFORNIA 92626 FAX (714) 668-4265 SUITE G-205 TEL (714) 668-4260		
PROGRESS PRINTS		
DRAWN: SH CHECKED: SC DATE: August 2006 JOB NO: 2494 FILE	© Gillis & Associates Architects All Rights Reserved This document and the structure depicted herein are the copyrighted property of, and may not be reproduced in any form without the express written permission of, Gillis & Associates.	