

MEETING DATE February 13 2006

AGENDA ITEM Consideration to Approve a Conceptual Design of the Police Firing Range and to Authorize the Advertising of Bids using the Design/Build format for Building Modifications and Equipment Installation

ATTACHMENTS



	<u>Pages</u>
1 Conceptual Design by Gillis & Associates	1-9
2 Public Notification Postcard	10

CULVER CITY RANGE

GILLIS & ASSOCIATES ARCHITECTS, INC

Donald Gillis, AIA
PRINCIPAL IN CHARGE

Jack Panichapan, AIA
PROJECT ARCHITECT

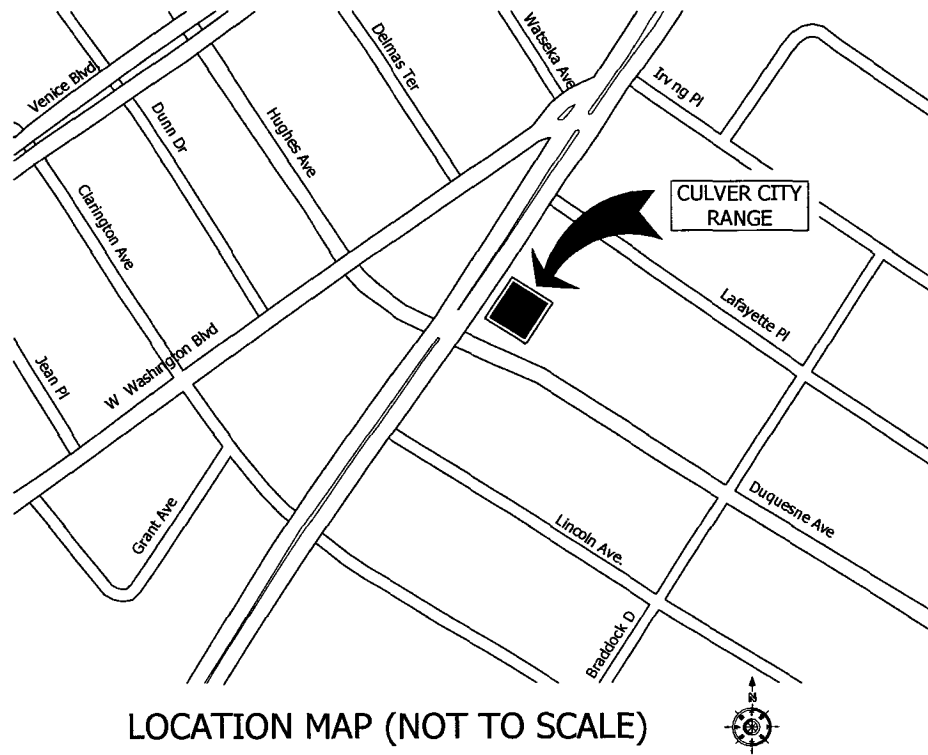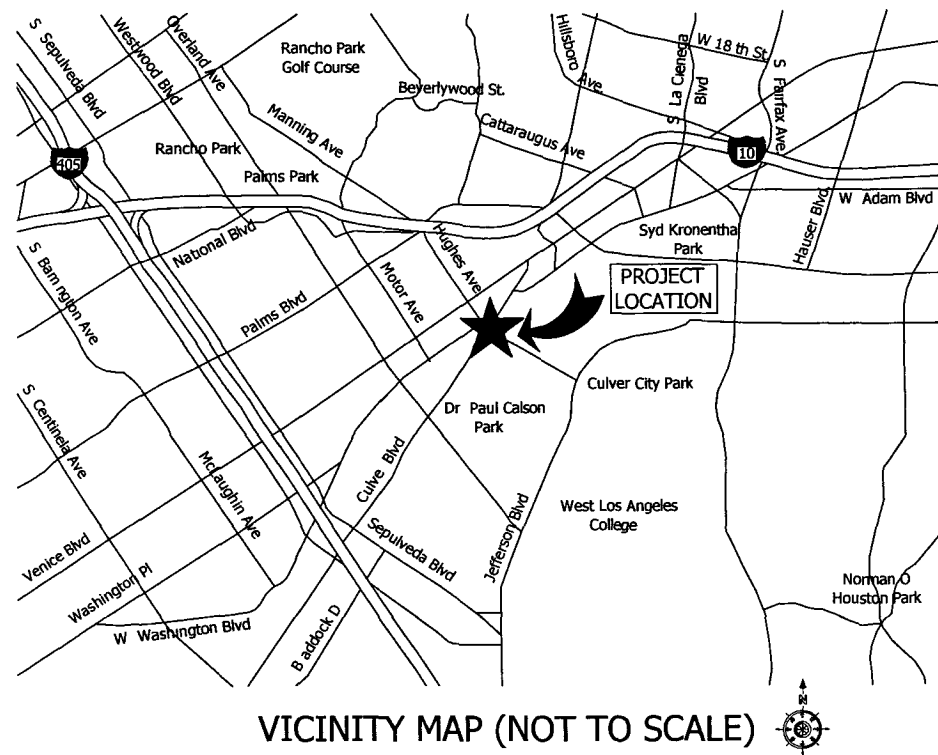

SHEET INDEX

ARCHITECTURAL CONCEPT DESIGN

- 1 Cover Sheet
- 2 Overall Floor Plan
- 3 Existing Floor Plan
- 4 New Floor Plan
- 5 Enlarged Floor Plan
- 6 Section
- 7 Power and Lighting Plan
- 8 Mechanical Floor Plan
- 9 Interior Elevations and Details

RENOVATION

PHASE II


9770 CULVER BOULEVARD, CULVER CITY, CA 90232-0507

[illegible]

Renovation

Culver City Range

Cover Sheet

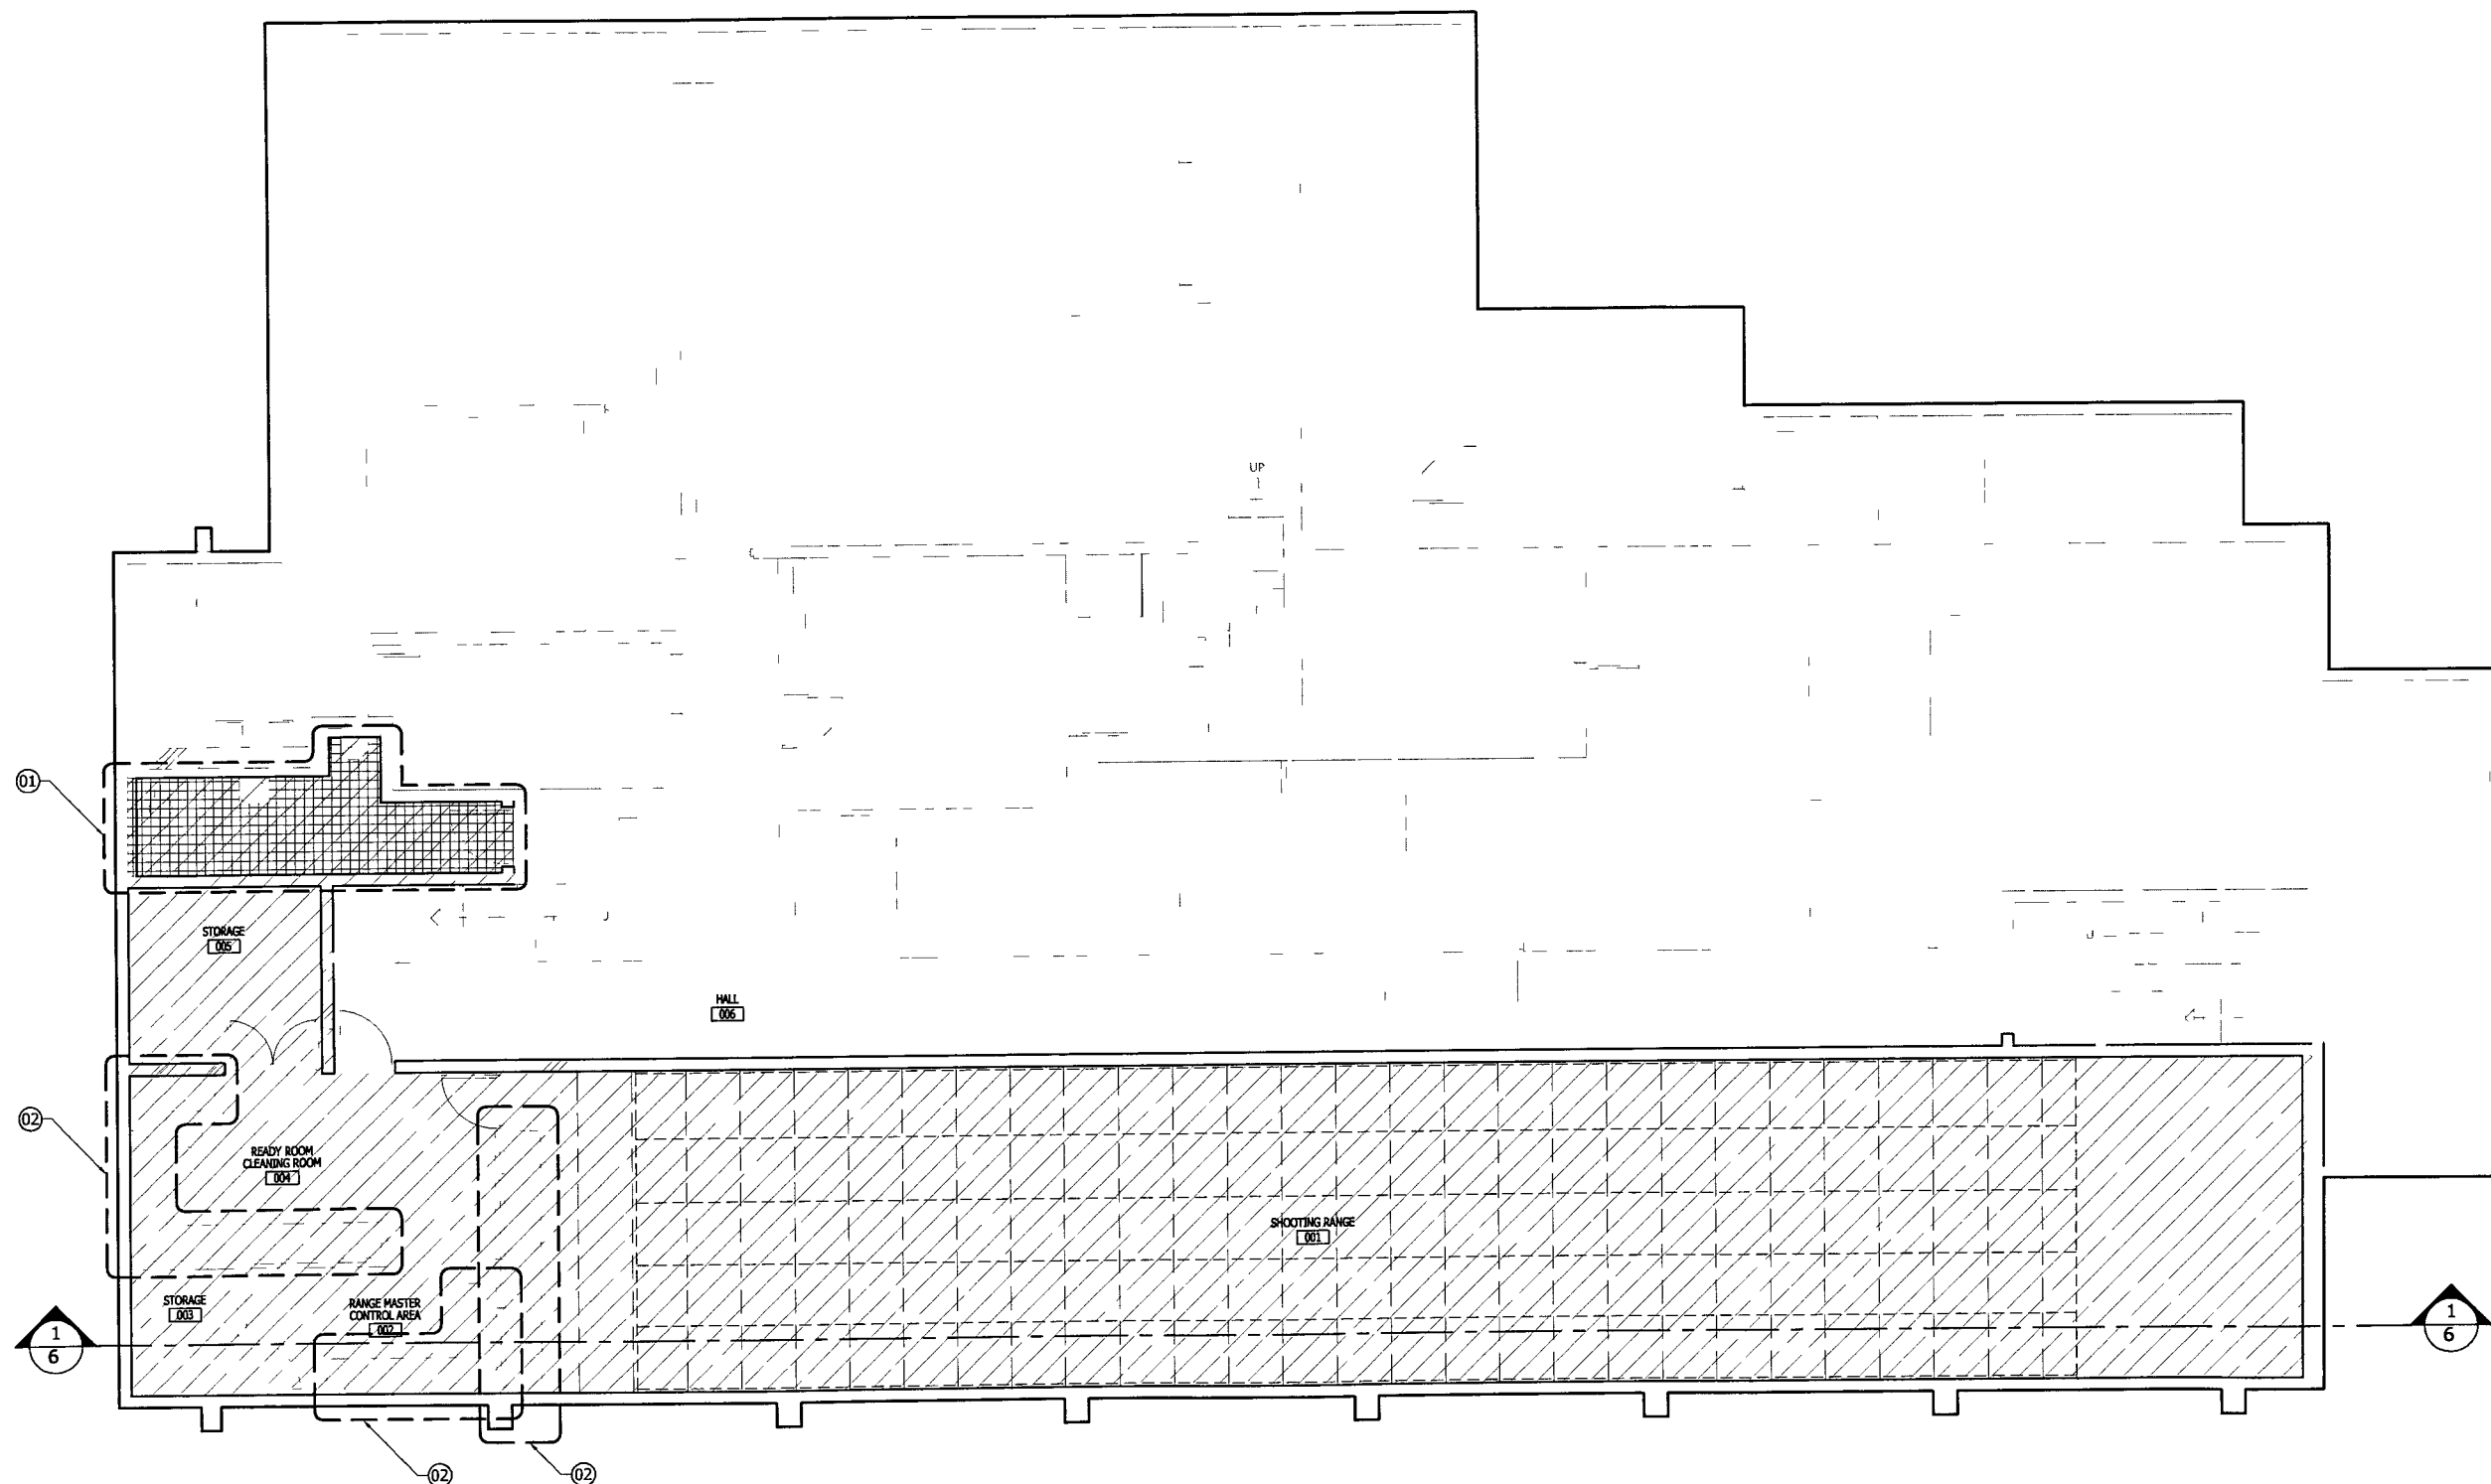

KEYNOTES

- 01 ADDITIVE ALTERNATE BID 1 TOILET ROOM IMPROVEMENT
- 02 ADDITIVE ALTERNATE BID 2 CASEWORK

LEGEND



GILLIS & ASSOCIATES
ARCHITECTS INC.

2900 BRISTOL STREET COSTA MESA CALIFORNIA 92626
FAX (714) 668-4265 SUITE G-205 TEL (714) 668-4260


REGISTERED PROFESSIONAL ARCHITECT
DONALD JOSEPH GILLIS
NO C 7955
EXP 11/30/05
STATE OF CALIFORNIA

PROGRESS PRINTS			
DRAWN	Staff	DATE	11/28/05
CHECKED		JOB NO	2404
SC FCTR		FILE	

© Gill & Associates Architects
All Rights Reserved
This document and the structure depicted herein are the copyrighted property of and may not be reproduced, in any form without the express written permission of Gill & Associates.

1 OVERALL FLOOR PLAN & SCOPE OF WORK
Scale 3/16" = 1'-0"

Renovation
Culver City Range

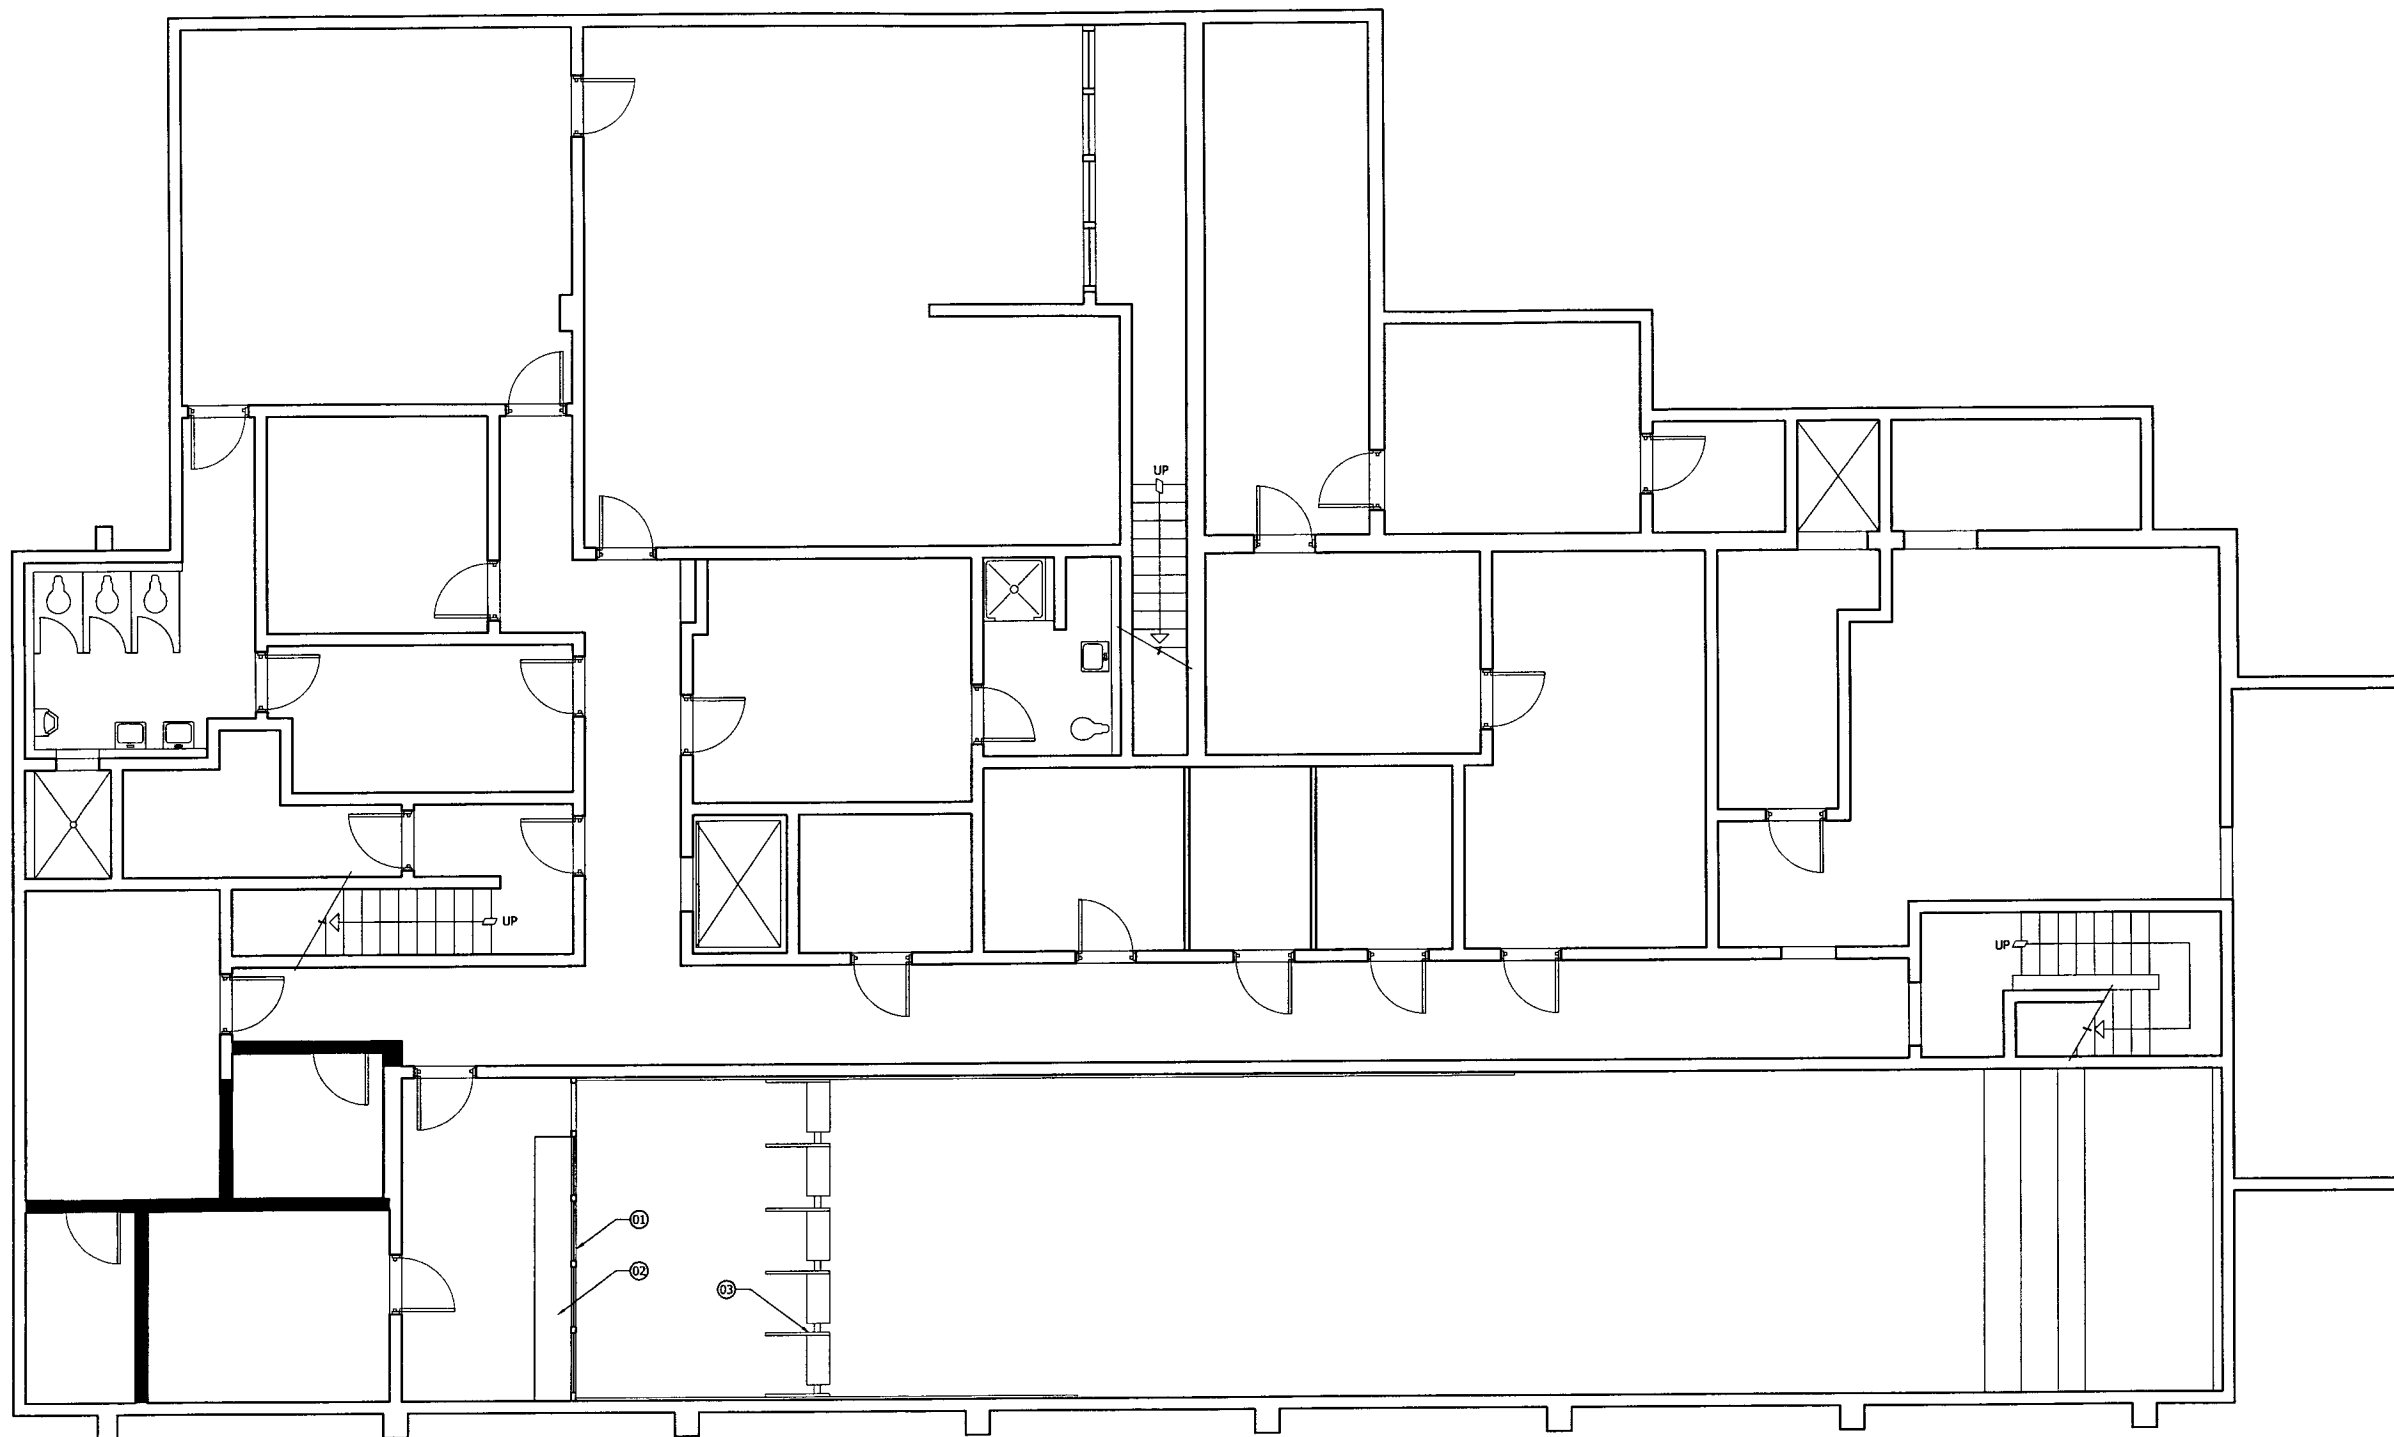

1 EXISTING AND DEMO FLOOR PLAN
 Scale 3/16 1'-0"

KEYNOTES

- 01 EXISTING PARTITION WALL TO BE REMOVED
- 02 EXISTING CASEWORK TO BE REMOVED
- 03 EXISTING SHOOTING STATIONS TO BE REMOVED

NOTES

DESIGN BUILD CONTRACTOR SHALL PROVIDE STRUCTURAL CALCULATIONS AND STRUCTURAL DESIGN TO SHOW REMOVAL OF THESE WALLS

LEGEND

EXISTING WALL TO BE REMOVED

GILLIS & ASSOCIATES ARCHITECTS INC. 2900 BRISTOL STREET COSTA MESA CALIFORNIA 92626 FAX (714) 668-4265 SUITE G 205 TEL (714) 668-4260		
PROGRESS PRINTS		
DRAWN Staff	DATE 11/28/05	Gillis & Associates Architects All rights reserved. The documents and the structure depicted here are the copyrighted property and may not be reproduced without the express written permission of its Associates.
CHECKED	JOB NO 2404	
SC FCTR	FILE	


Renovation
 Culver City Range

NOTES

- 1 STRUCTURAL CHANGES TO THE BUILDING
- 2 PROVIDE AND INSTALL HELICAL BULLET TRAP
- 3 PROVIDE AND INSTALL OVERHEAD BAFFLES
- 4 PROVIDE AND INSTALL NEW HVAC SYSTEM
- 5 PROVIDE AND INSTALL REQUIRED ELECTRICAL
- 6 PROVIDE AND INSTALL BALLISTIC RUBBER WALL SURFACE
- 7 PROVIDE AND INSTALL BULLET PROOF GLASS, DOOR, FRAMES AND BULLET PROOF FIBERGLASS MATERIAL
- 8 PROVIDE AND INSTALL NEW BATHROOM AS SHOWN ON DRAWINGS (ALT BID 1)
- 9 CASEWORK ALTERNATE BID 1

KEY NOTES

- 01 CLOSE OPENING WITH MASONRY
- 02 ENLARGE OPENING AND INSTALL NEW BULLET PROOF GLASS AND BULLET FRAMES
- 03 NEW CASEWORK
- 04 LINES DENOTE LANES FOR RANGE (NO ACTUAL STRIPING)
- 05 NEW TILE FLOOR, 48" HIGH CERAMIC TILE WAINSCOT
- 06 NEW URINAL
- 07 NEW LAVATORY
- 08 NEW WATER CLOSET
- 09 NEW HVAC SYSTEM
- 10 HELICALL BULLET TRAP
- 11 PORTABLE AIR COMPRESSOR
- 12 AIR COMPRESSOR OUTLET
- 13 NEW BULLET PROOF DOOR AND FRAME
- 14 BALLISTIC RUBBER WALL SURFACE
- 15 NEW CARPETING W/ TOPSET BASE IN ALL SMALL ROOMS
- 16 EXISTING CONCRETE FLOOR
- 17 OVERHEAD BAFFLES

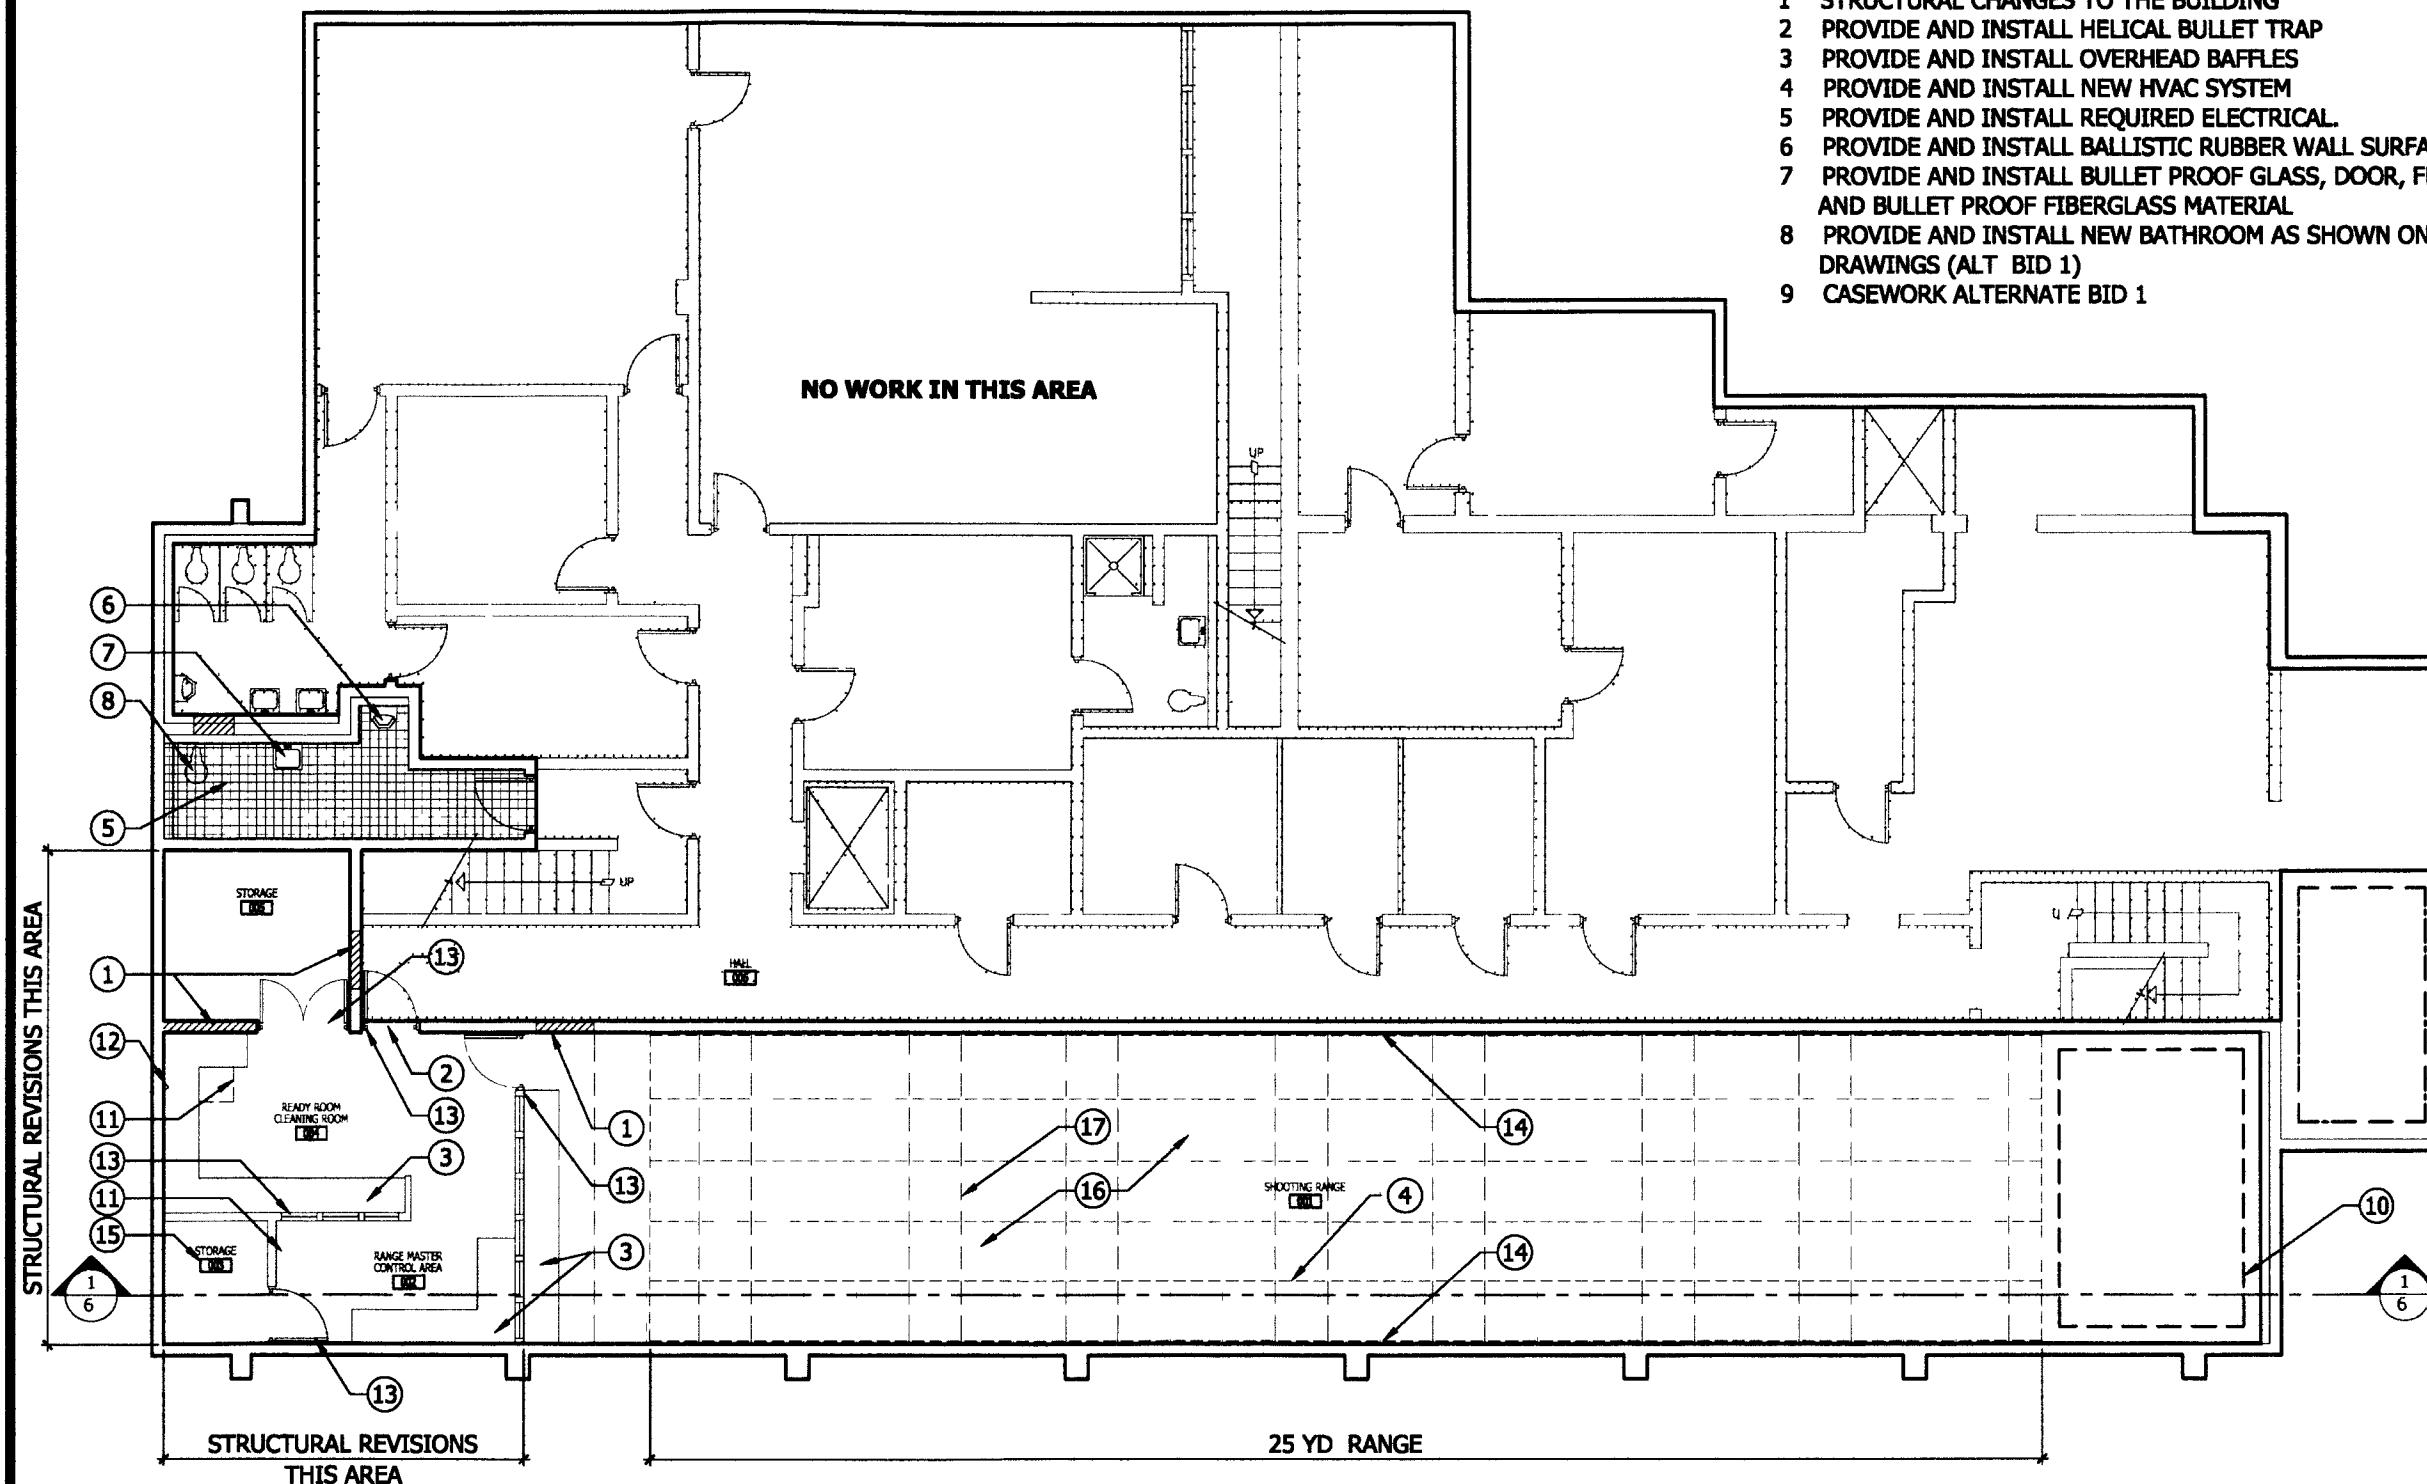


1 NEW FLOOR PLAN
Scale 3/16" = 1'-0"


GILLIS ASSOCIATES ARCHITECT & INC. 2900 BRISTOL STREET COSTA MESA CALIFORNIA 92626 FAX (714) 668-4265 SUITE G-203 TEL (714) 668-4260		
PROGRESS PRINTS		
DRAWN: [] CHECKED: [] BY: []	DATE: 11/28/05 JOB NO.: 2404 FILE: []	This document and the drawings depicted herein are the copyrighted property of Gillis & Associates. Any use without the express written permission of Gillis & Associates is prohibited.

Renovation
Culver City Range

New Floor Plan

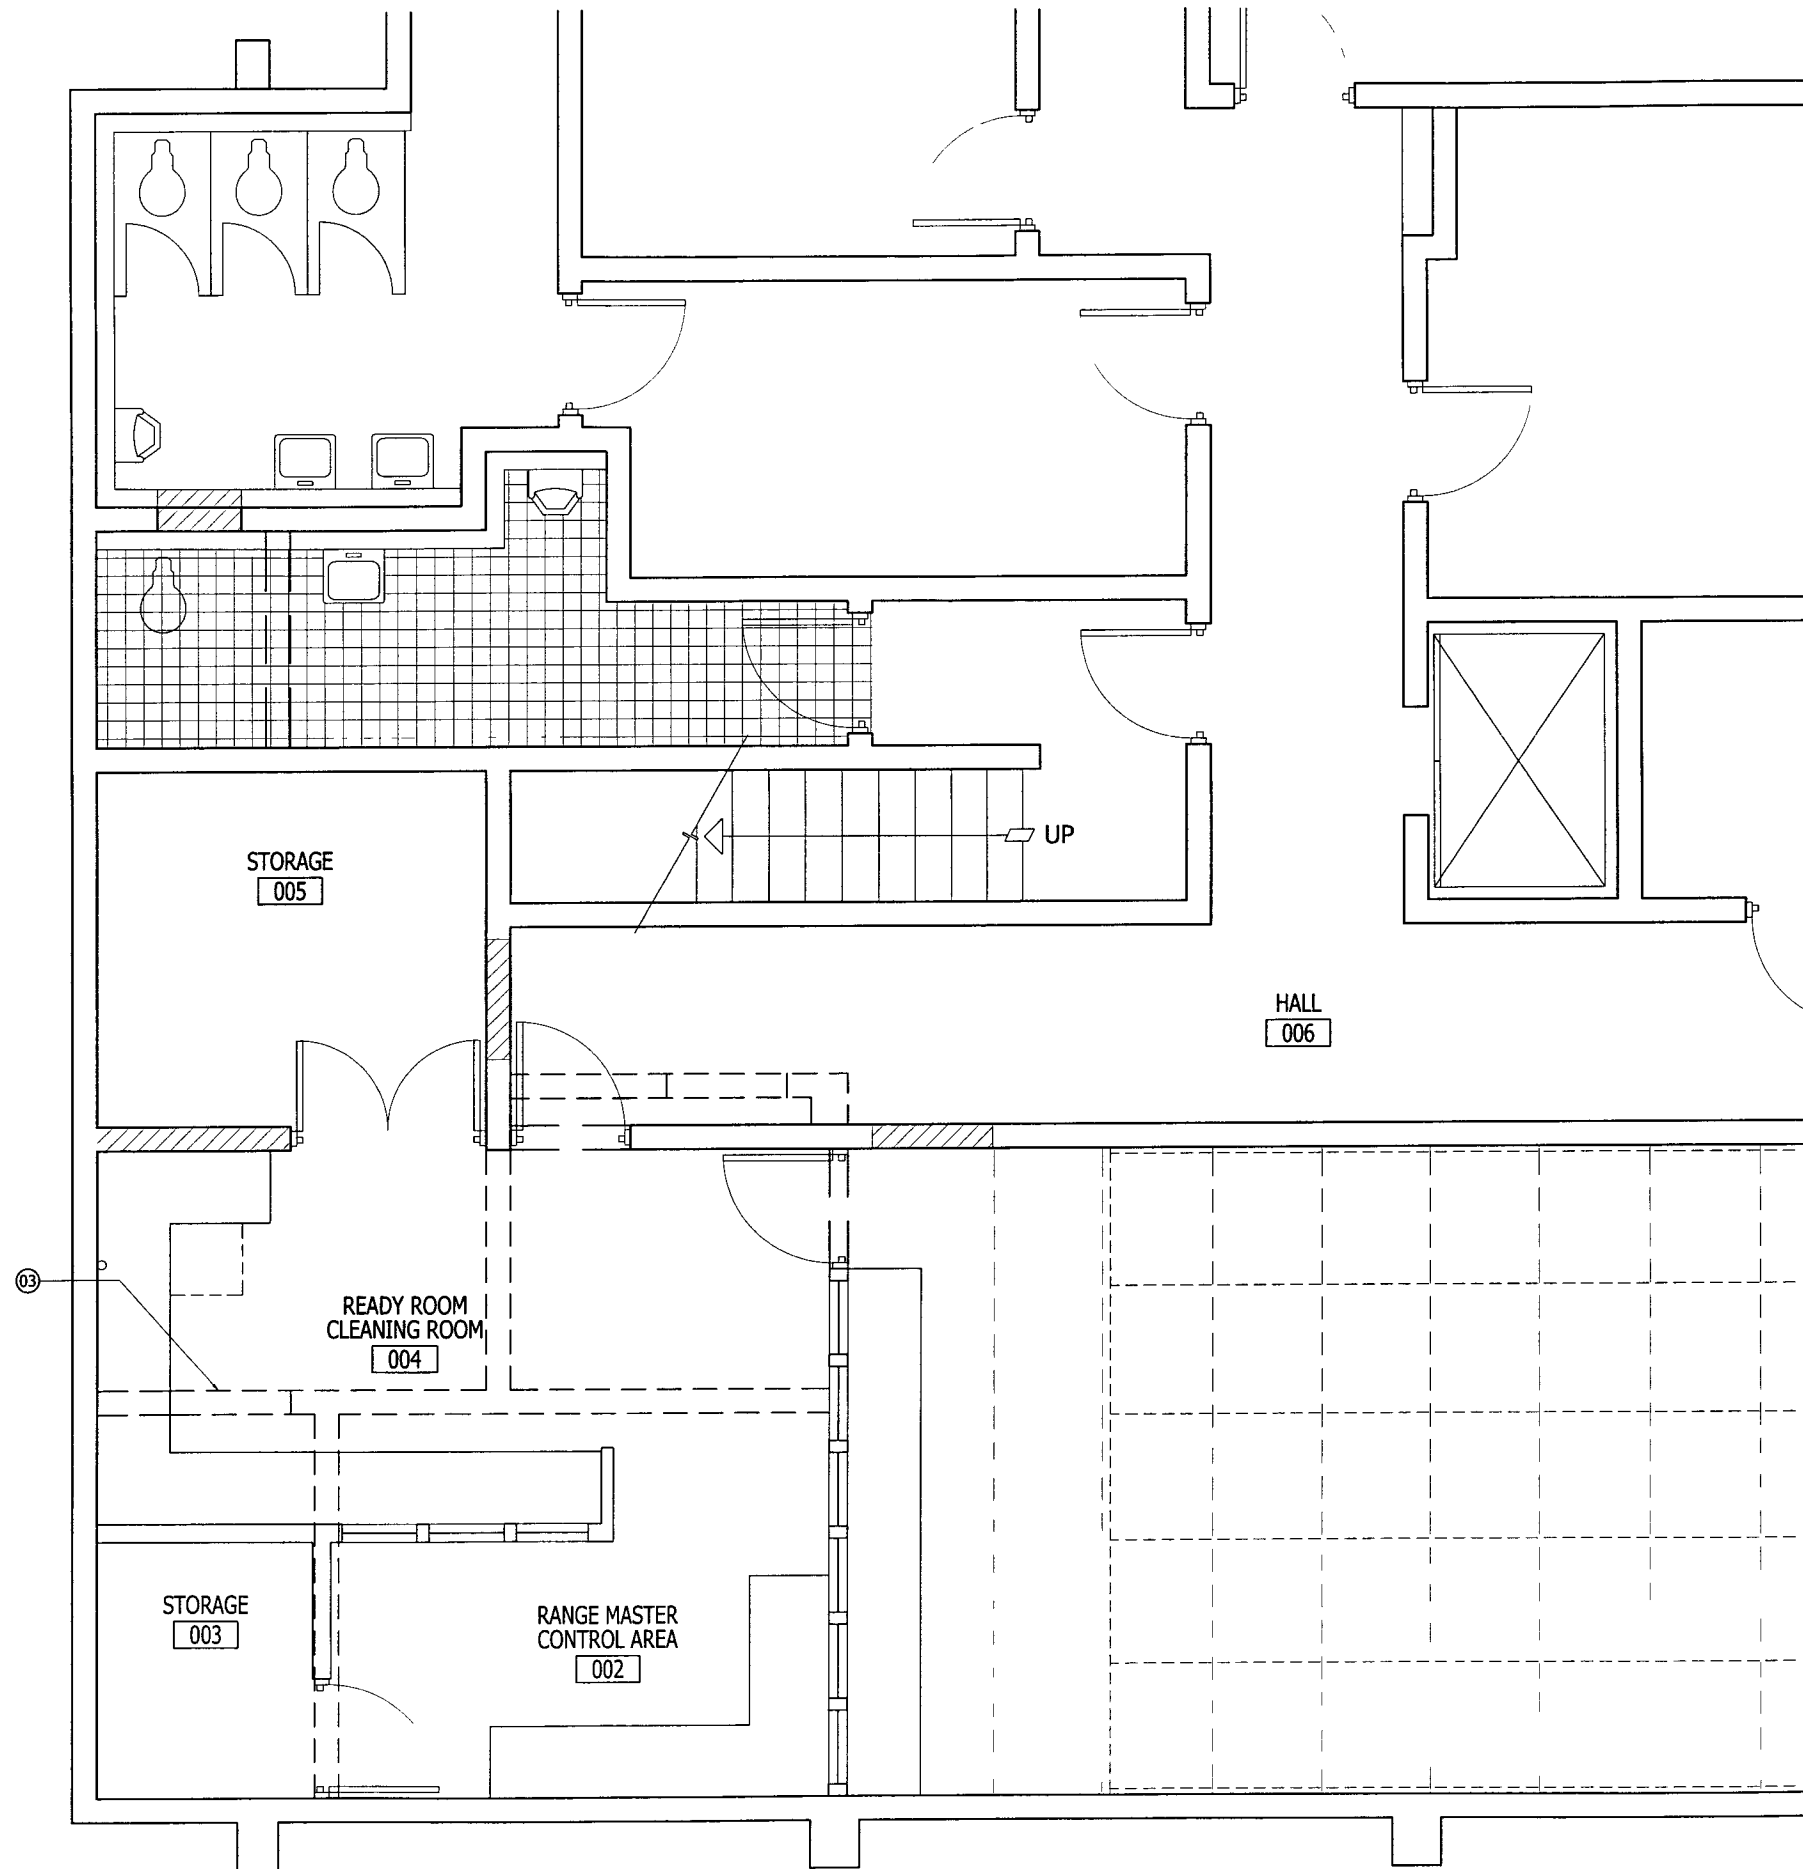

1 ENLARGED NEW FLOOR PLAN
Scale 3/8" = 1'-0"

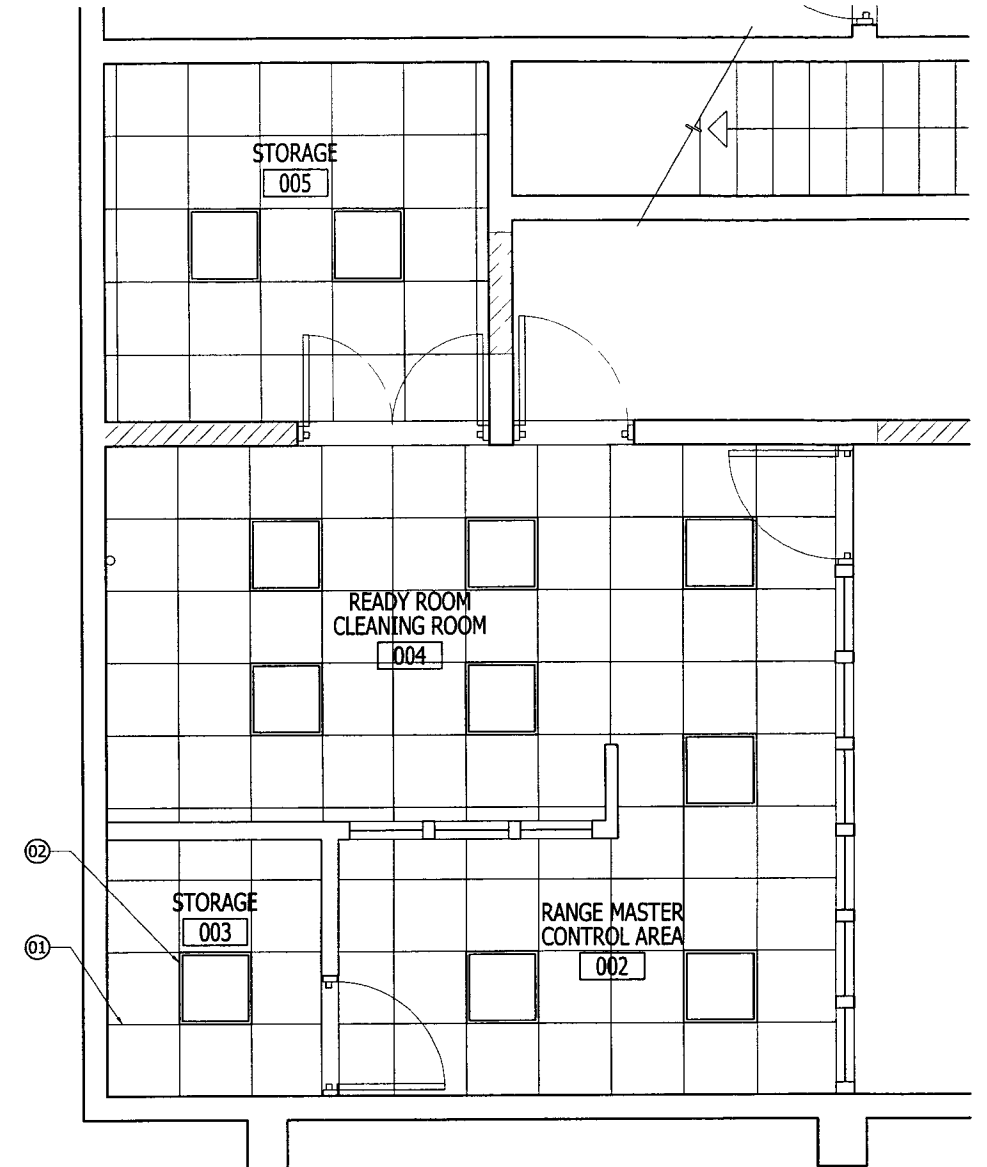

2 PARTIAL REFLECTED CEILING PLAN
Scale 3/8" = 1'-0"

KEYNOTES

- 01 2' X 2' CEILING GRID W/ ACOUSTICAL TILES
- 02 RECESSED 2' X 2' FIXTURE IN ACCESSIBLE CEILING
- 03 EXISTING WALLS TO BE REMOVED SEE SHEET EXISTING AND DEMO PLAN

GILLIS ASSOCIATES
ARCHITECTS INC.


2900 BRISTOL STREET COSTA MESA, CALIFORNIA 92626
FAX (714) 668-4265 SUITE G 205 TEL (714) 668-4260

REGISTERED PROFESSIONAL ARCHITECT
DONALD JOSEPH GILLIS
NO. C 7955
EXPIRES 11/30/05
STATE OF CALIFORNIA

PROGRESS PRINTS	
DRAWN: Staff	DATE: 11/28/05
CHECKED:	JOB NO: 2404
SC: FCTR	FILE:

This document and the structure depicted herein are the copyrighted property of Gillis Associates. No part of this document may be reproduced without the express written permission of Gillis Associates.

Renovation
Culver City Range

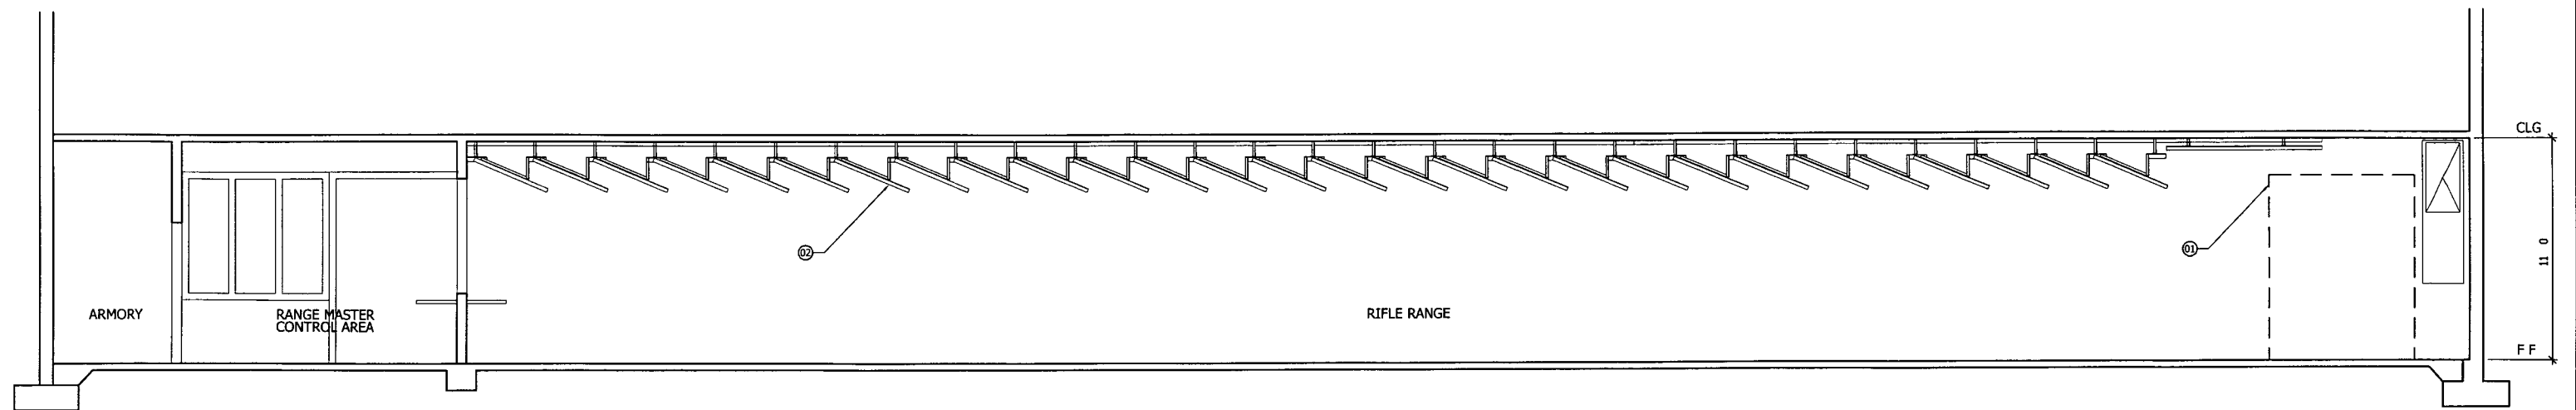


1 SECTION
Scale 1/4" = 1'-0"

KEYNOTES

- 01 HELICAL BULLET TRAP SEE SPECIFICATION SECTION 11501
02 PROTECTIVE BAFFLES REFER TO SPECIFICATIONS SECTION 11505

GILLIS & ASSOCIATES ARCHITECTS INC 2900 BRISTOL STREET COSTA MESA CALIFORNIA 92626 FAX (714) 668-4265 SUITE G 205 TEL (714) 668-4260		
PROGRESS PRINTS		
DRAWN Staff	DATE 11/28/05	This document and structure depicted here are the copyrighted property of Gillis & Associates and may not be reproduced in any form without the express written permission of Gillis & Associates
CHECKED	JOE NO 2404	
SC FCTR	FILE	

Renovation
Culver City Range

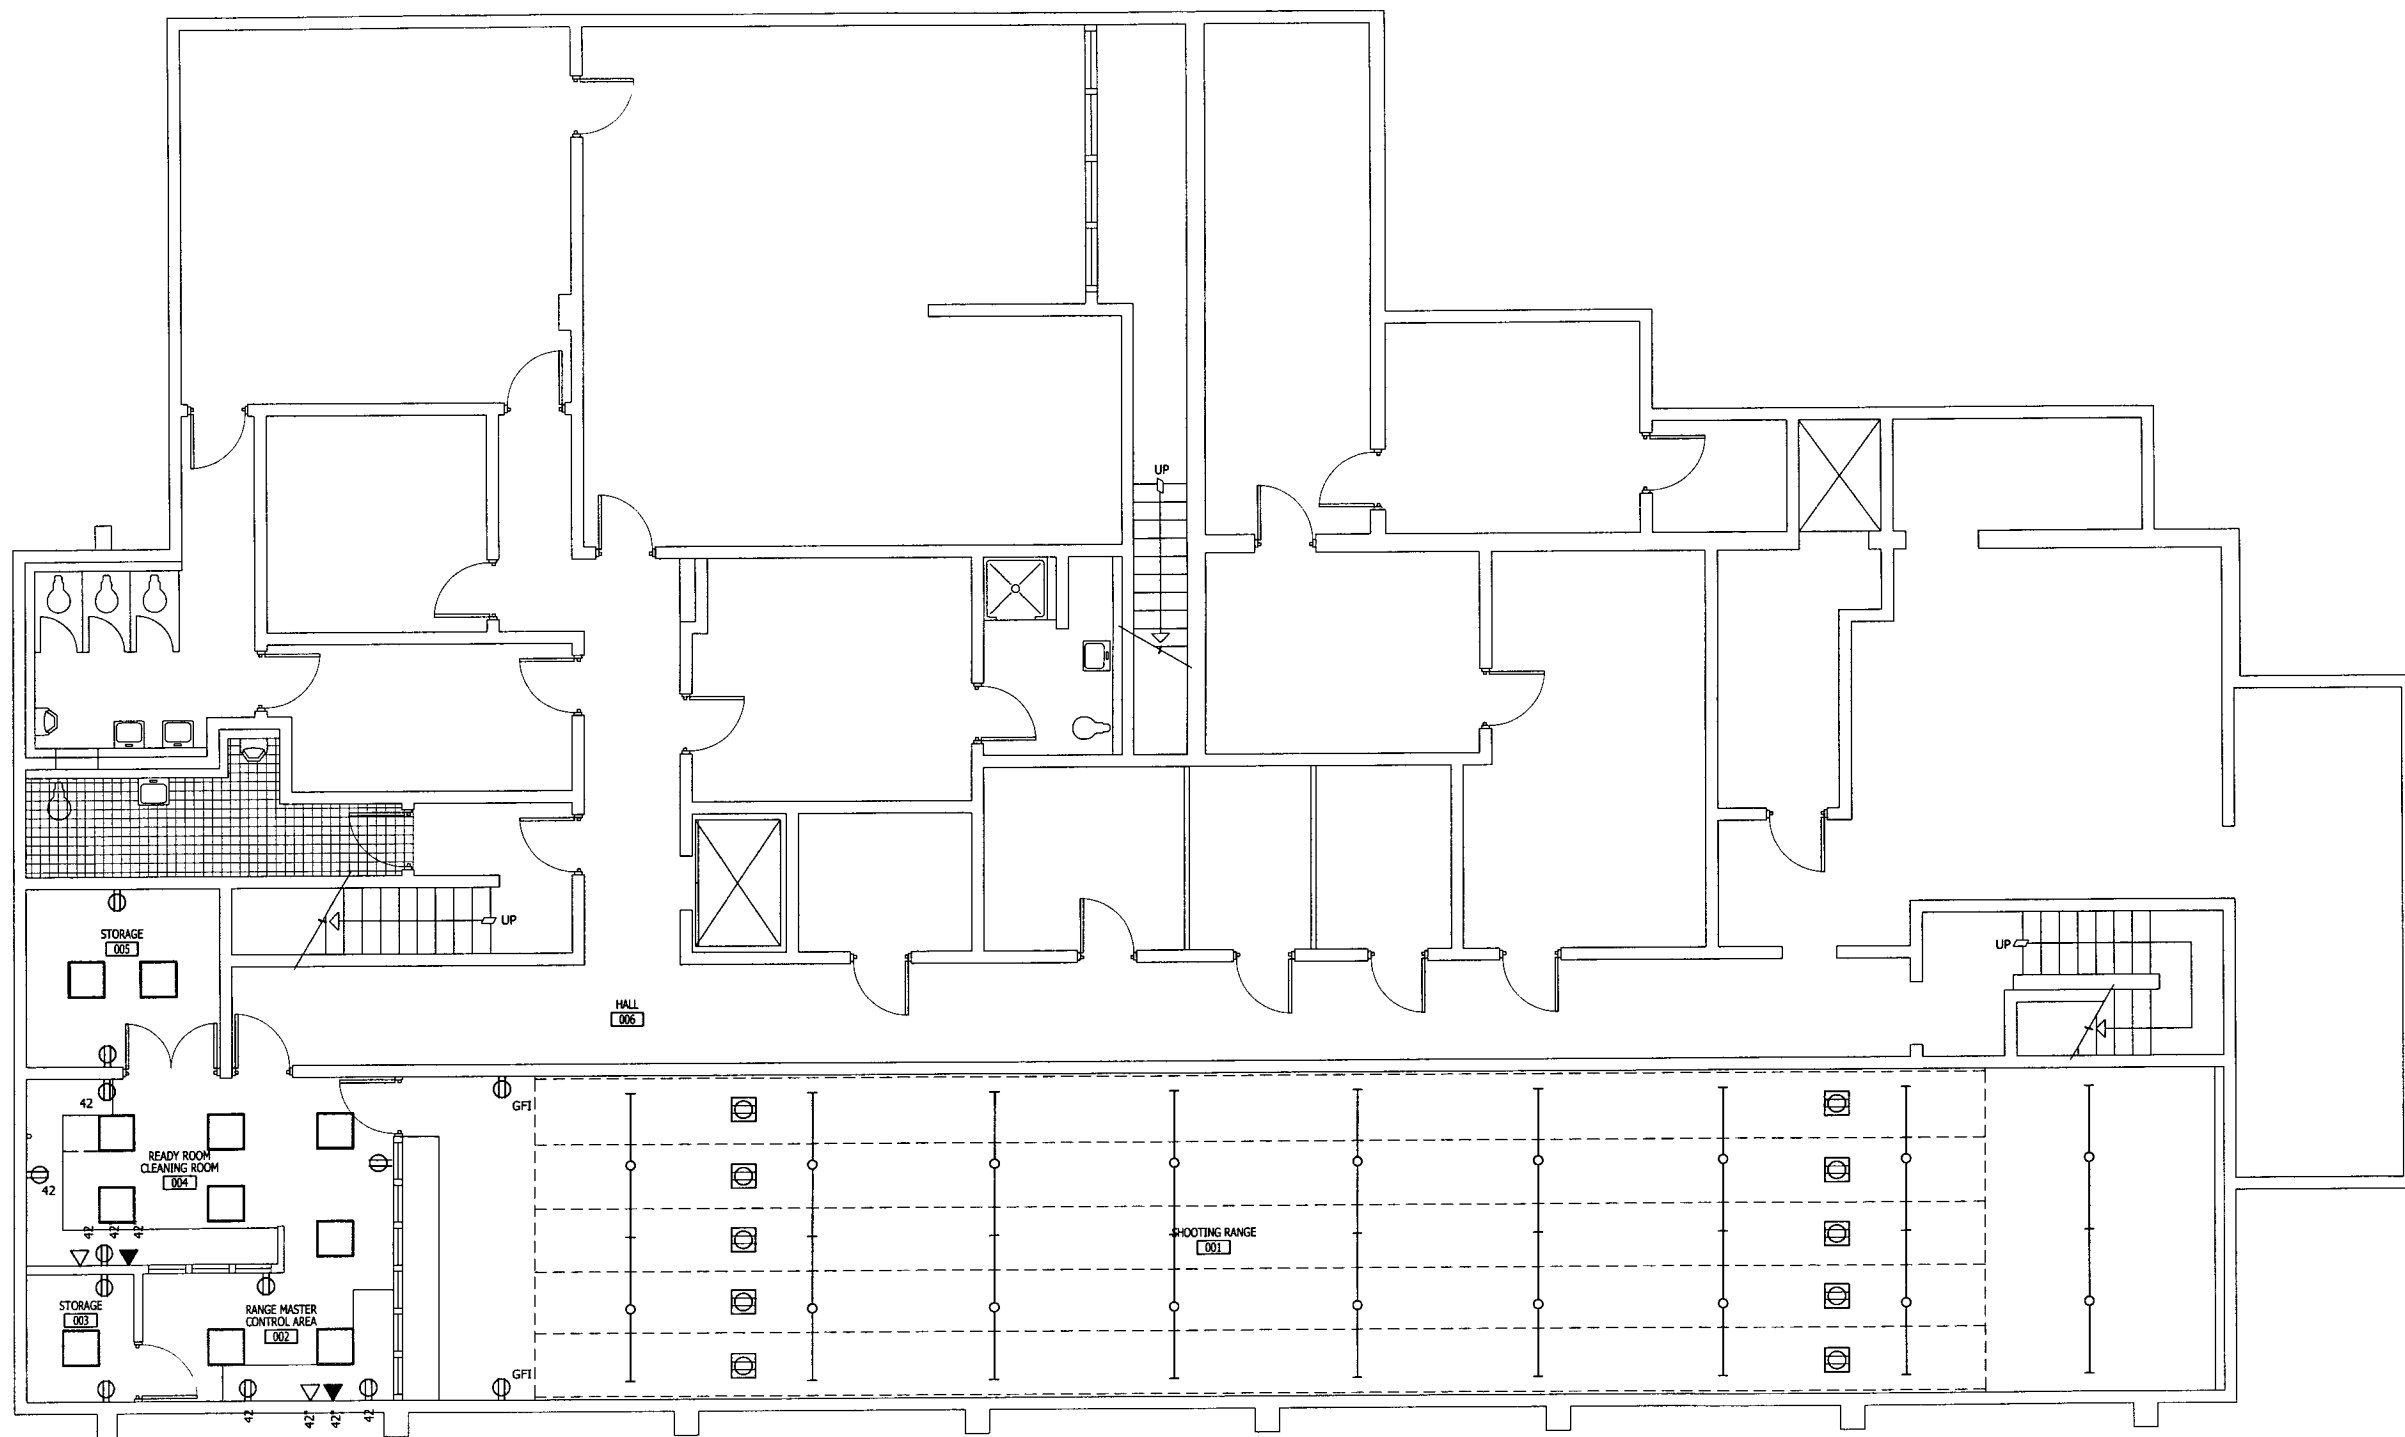

NOTE

ALL ELECTRICAL COMPONENTS AND CONDUITS
OUTSIDE OF RANGE CAN BE SURFACE MOUNTED

ELECTRICAL LEGEND

- CEILING MOUNTED RECEPTACLE @ 60 FOOT LINE
FOR MOTORIZED TARGETING SYSTEM (TYP 5 QTY
EACH LINE)
- DUPLEX RECEPTACLE WALL MOUNTED AT +18' A.F.F.
OR AS NOTED
- GFI GROUND FAULT INTERRUPTER RECEPTACLE
WALL MOUNTED AT +18' A.F.F. OR AS NOTED
- TELEPHONE OUTLET BOX WALL MOUNTED AT 18' A.F.F.
(MIN) OR AS NOTED STUB A 3/4" C.O. UP 6" ABOVE
THE ACCESSIBLE CEILING AND PROVIDE A BUSHING
45/DP MINIMUM W/ SINGLE GANG RING
- DATA OUTLET BOX MOUNTED AT 18' A.F.F. (MIN)
OR AS NOTED STUB A 3/4" C.O. UP 6" ABOVE
THE ACCESSIBLE CEILING AND PROVIDE A BUSHING
45/DP MINIMUM W/ SINGLE GANG RING
- COMMERCIAL WIDE STRIP FLUORESCENT FIXTURE
ELECTRONIC BALLAST U.L. LISTED SPECIAL
DIMMING BALLASTS FROM LUTRON
- RECESSED 2'x2' FIXTURE IN ACCESSIBLE CEILING

GILLIS & ASSOCIATES
ARCHITECTS INC.


2900 BRISTOL STREET COSTA MESA CALIFORNIA 92626
FAX (714) 668-4265 SUITE G 205 TEL (714) 668-4260

REGISTERED PROFESSIONAL ARCHITECT
DONALD JOSEPH GILLIS
NO. C 7955
STATE OF CALIFORNIA
EXP. 11/30/05


PROGRESS PRINTS	
DRAWN Staff	DATE 11/28/05
CHECKED	JOB NO. 2404
SC PCTR	FILE

Gillis Associates Architects
All rights reserved.


This document and the structure cited herein are the
copyrighted property and may not be reproduced in any form
without the express written permission of Gillis Associates

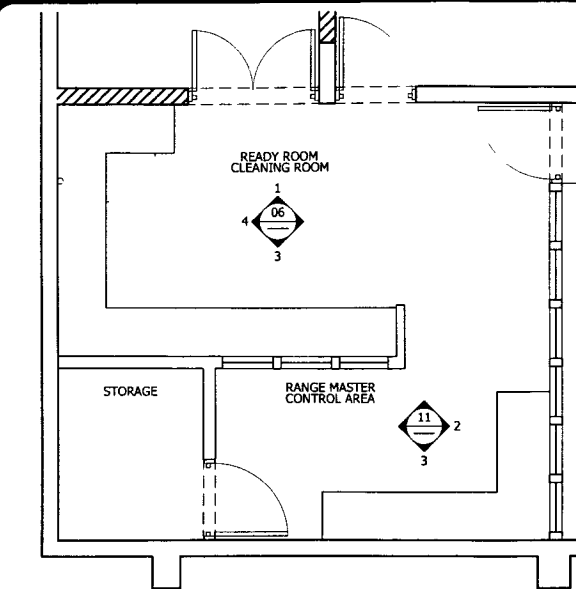


01 PARTIAL PLAN
Scale 3/4 1-0

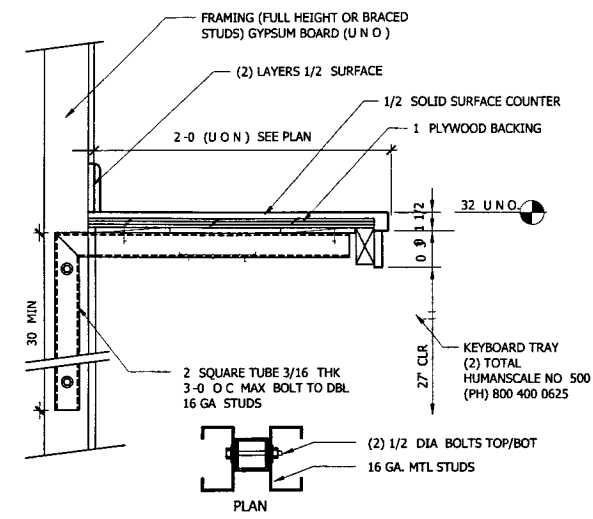


02 SOLID SURFACE COUNTER
Scale 1 1/2 1-0

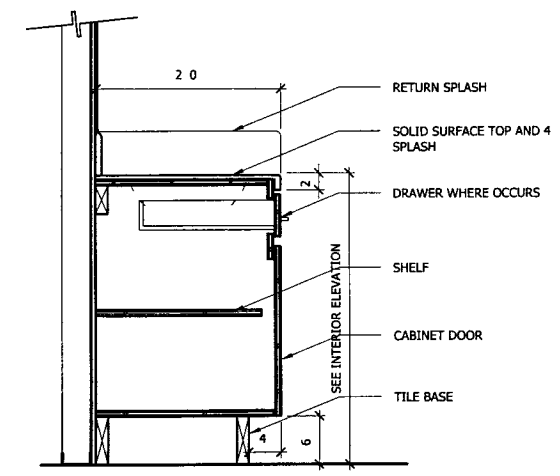


03 COUNTER TOP
Scale 1 1-0

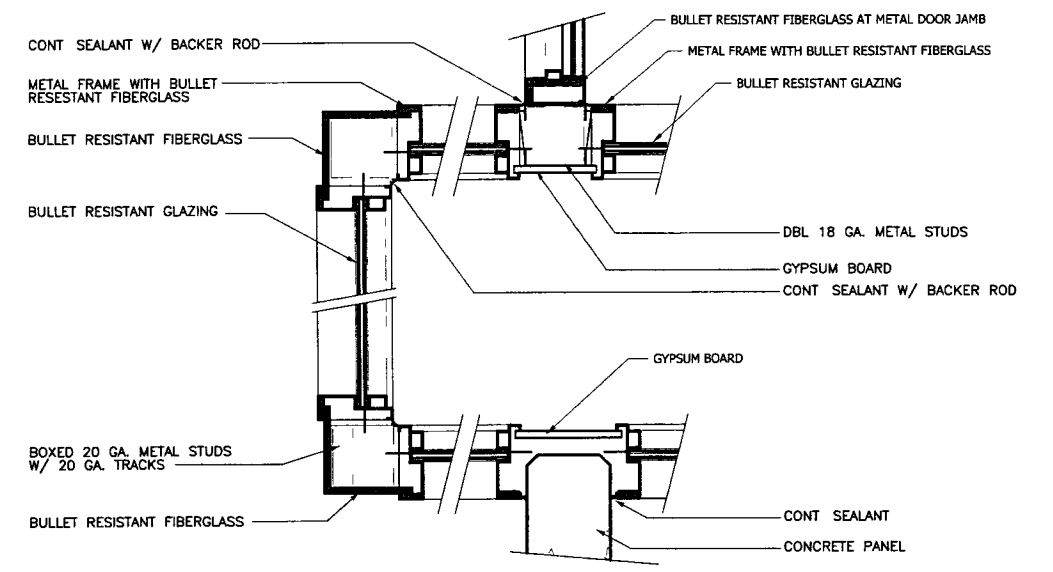


04 BULLET RESISTANT WINDOW FRAME (PLAN)
Scale 1 1/2 1-0

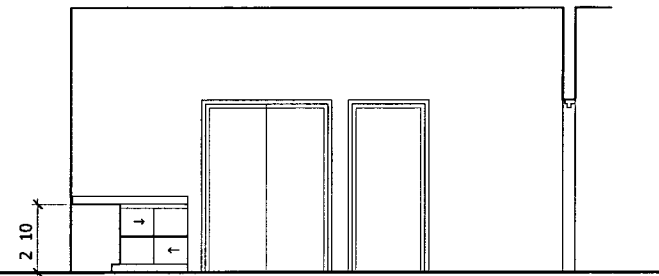


06 READY ROOM/CLEANING ROOM
Scale 1/4 1-0

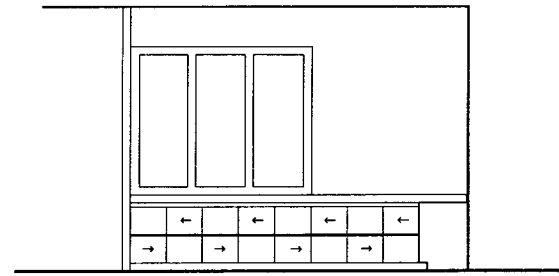


03

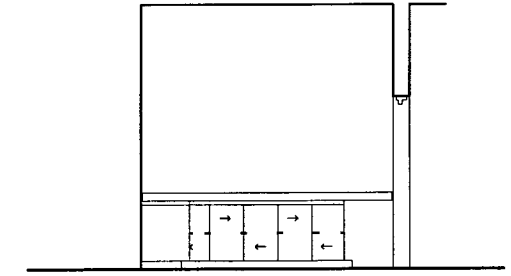


04

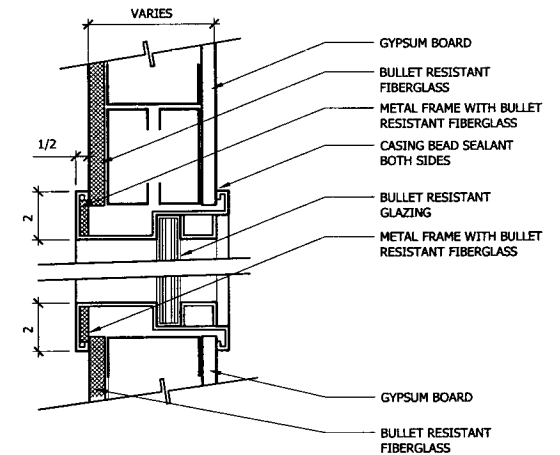


09 BULLET RESISTANT WND FRAME (HEAD JAMB SIM)
Scale 3/4 1-0

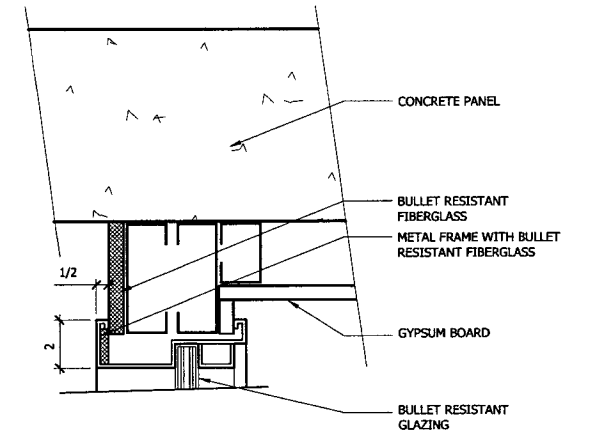


10 BULLET RESISTANT WINDOW FRAME
Scale 3/4 1-0

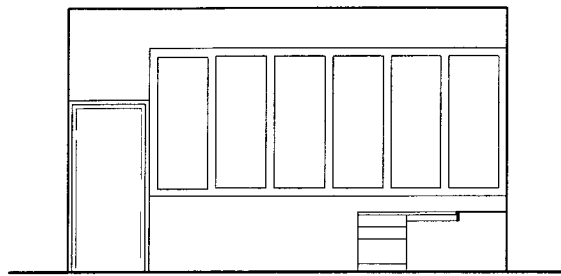


11 RANGE MASTER/CONTROL AREA
Scale 1/4 1-0

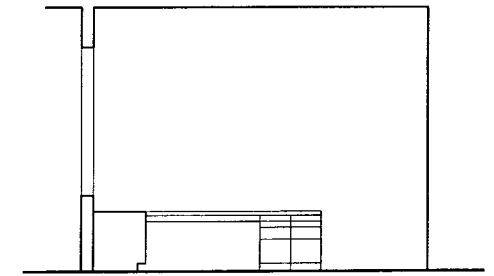

03

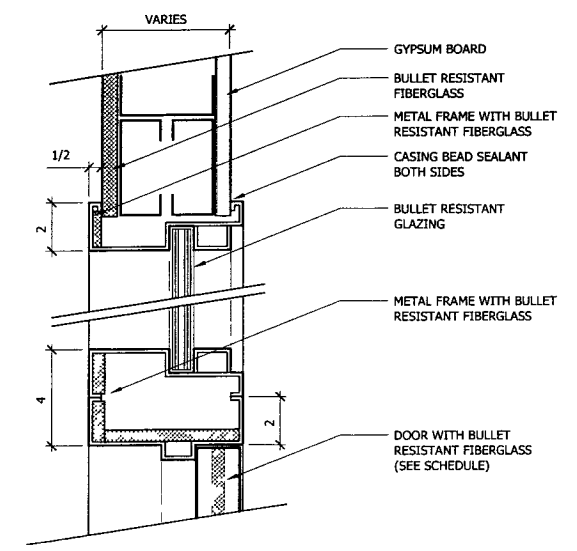

13 BULLET RESISTANT DR FRAME (HEAD JAMB SIM)
Scale 3/4 1-0

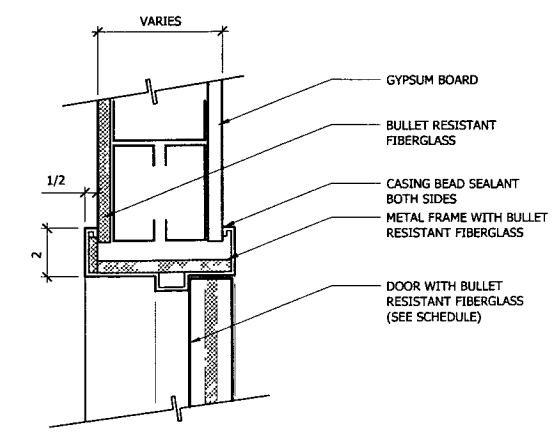

14 BULLET RESISTANT DR FRAME (HEAD JAMB SIM)
Scale 3/4 1-0



GILLIS & ASSOCIATES
ARCHITECTS INC

2900 BRISTOL STREET COSTA MESA CALIFORNIA 92626
FAX (714) 668-4265 SUITE G 205 TEL (714) 668-4260

REGISTERED PROFESSIONAL ARCHITECT
DONALD JOSEPH GILLIS
NO C 7955
EXP 11 30 05
STATE OF CALIFORNIA

PROGRESS PRINTS	
DRAWN Staff CHECKED SC FCTR	DATE 11/28/05 JOB NO 2404 FILE
This document and the structure depicted here are the copyrighted property of Gillis & Associates, Inc. and may not be reproduced without the express written permission of Gillis & Associates, Inc.	

PUBLIC WORKS DEPARTMENT
CITY OF CULVER CITY
PO Box 507
9770 CULVER BOULEVARD
CULVER CITY CA 90232 0507

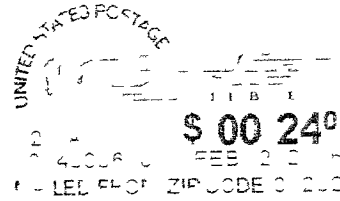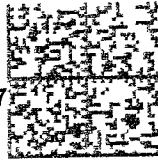

NOTIFICATION OF IMPORTANT CITY COUNCIL AGENDA ITEM
Police Firing Range



**NOTIFICATION OF IMPORTANT
AGENDA ITEM AT A FUTURE
COUNCIL MEETING**

The City Council will consider the
following agenda item at their meeting of

February 13 2005 Time 7 00 pm

**The City Council will consider
approving a Conceptual Design and
authorizing the advertisement for
Requests for Qualifications for a
Design/Build Team for the Upgrade
of the Police Department Firing
Range**

For more information contact

Dan Garcia
Project Manager

Location

City Hall

Mike Balkman Council Chambers
9770 Culver Boulevard
Culver City CA 90232

City Council/Agency meetings can be
viewed live on Channel 35 by most
Comcast subscribers Meetings are
also broadcast on the City's Radio
Station AM 1690

Visit the Culver City Website at
www.culvercity.org or send your ques-
tions or comments to the City at
chief.administration@culvercity.org
To view the Council meetings on line
please visit [http://www.culvercity.org/
webcast](http://www.culvercity.org/webcast)

To add your name to the City's email
list to receive agenda reports and news
of City issues please call (310) 253
6000 or complete an online request at
[http://www.culvercity.org/citygov/
public_notification.html](http://www.culvercity.org/citygov/public_notification.html)